


REFERENCES

NOTE

سایز لوله های اسپلیت ها میبایست توسط وندور نهایی گردد.

KEY PLAN

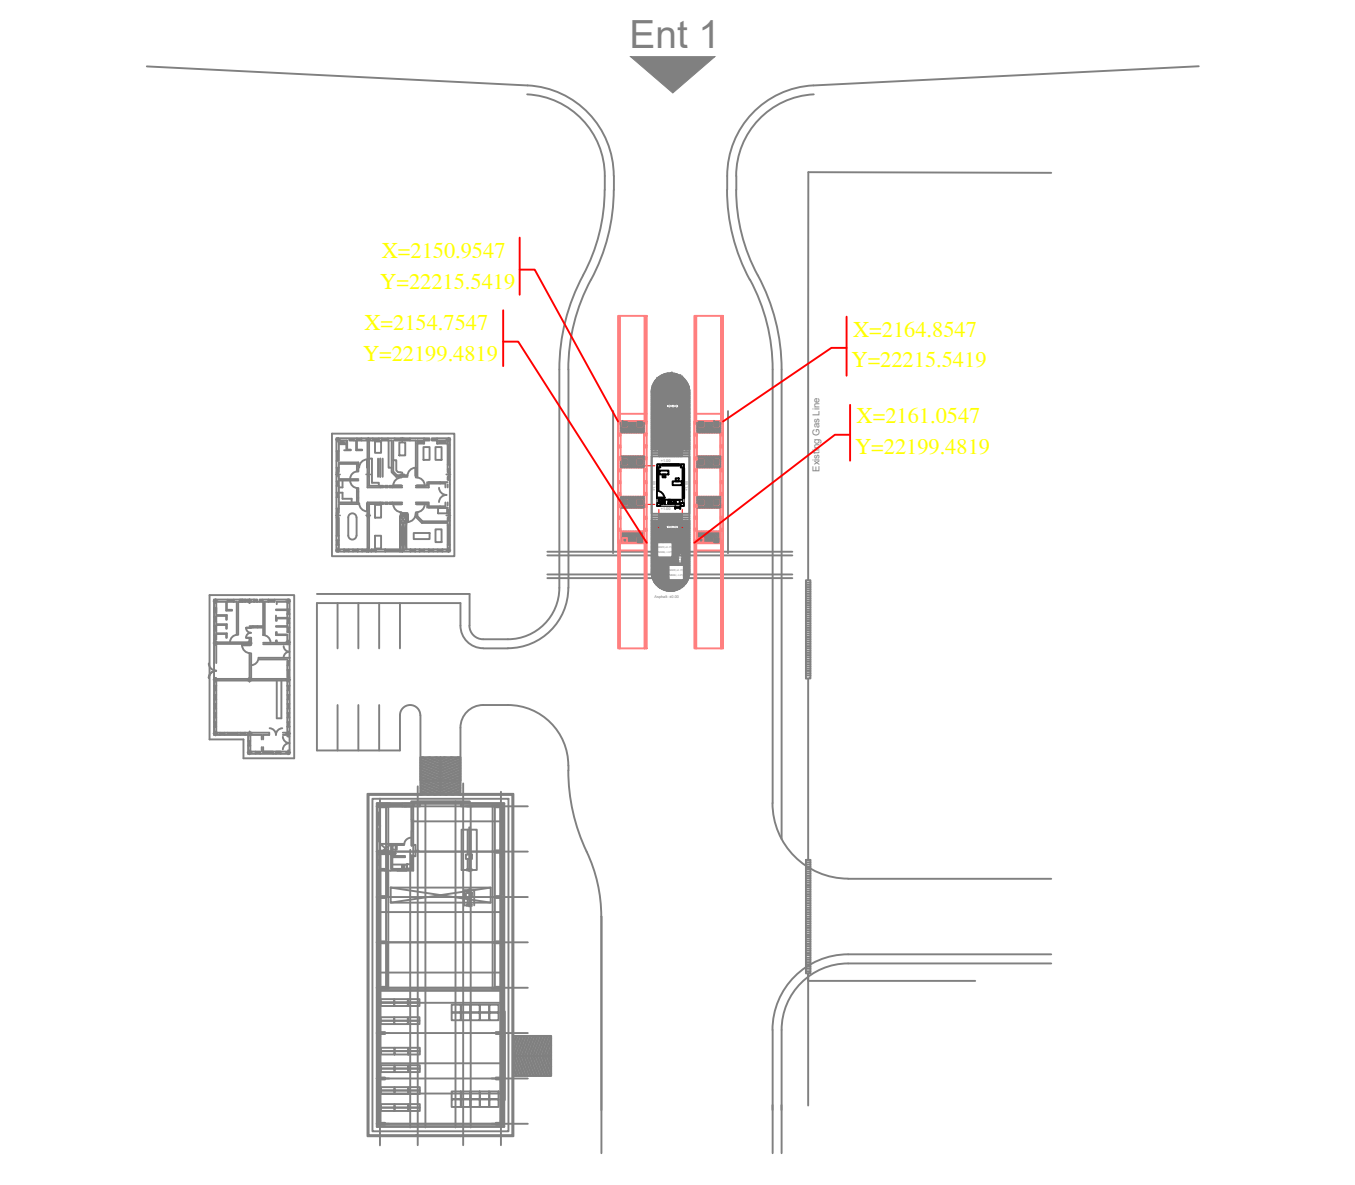

-	-	-		-	-
Rev.	Date	Revisions description	Prepared	Checked	Approved

for APPROVAL

CLIENT:

Golgothar Iron & Steel Development Co.
شرکت توسعه آهن و فولاد گل گهر
G.I.S.D.Co.



CLIENT:

Golgothar Iron & Steel Development Co.
شرکت توسعه آهن و فولاد گل گهر
G.I.S.D.Co.



CONSULTANT:

BARSOO  **برسو**
CONSULTING and PROJECT MANAGEMENT **شرکت مهندسی**

CONSULTANT:

BARSOO  **برسو**
CONSULTING and PROJECT MANAGEMENT **شرکت مهندسی**

CONTRACTOR:

SUBCONTRACTOR:

	Name	Date:	Sign.	CLIENT DOC . NO.	
Approved:	AM.MONFARED	1405/04/08			
Checked:	F.RONAGH	1405/04/08		PROJECT NO.:	
Designed:	J.SHARIF	1405/04/06		SCALE as shown	DOC CLASS NO.: --




PROJECT: WEST WEIGHING STATION

DRAWING TITLE:

COOLING & HEATING SYSTEM PLAN


DRAWING NO.

REGION CODE	PROJECT CODE	SUB PHASE CODE	AREA CODE	UNIT CODE	DOC TYPE CODE	DISCIPLINE CODE	SERIAL NO	REV	SIZE	SHEET
S	LM01	D	LIM	WHS	DWG	UT	002	0	A1	1/1

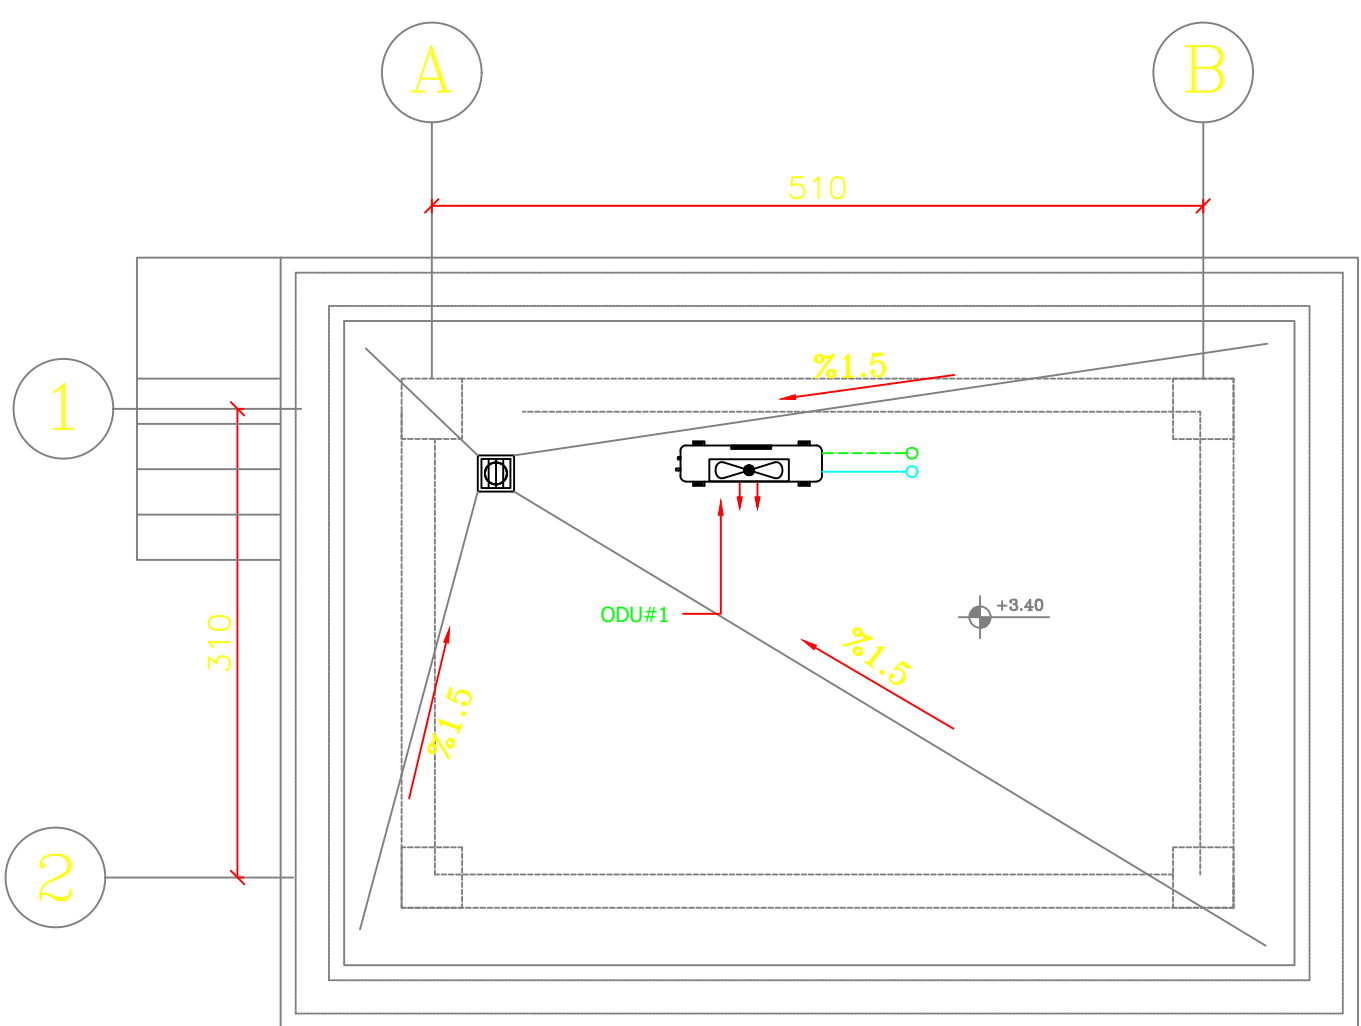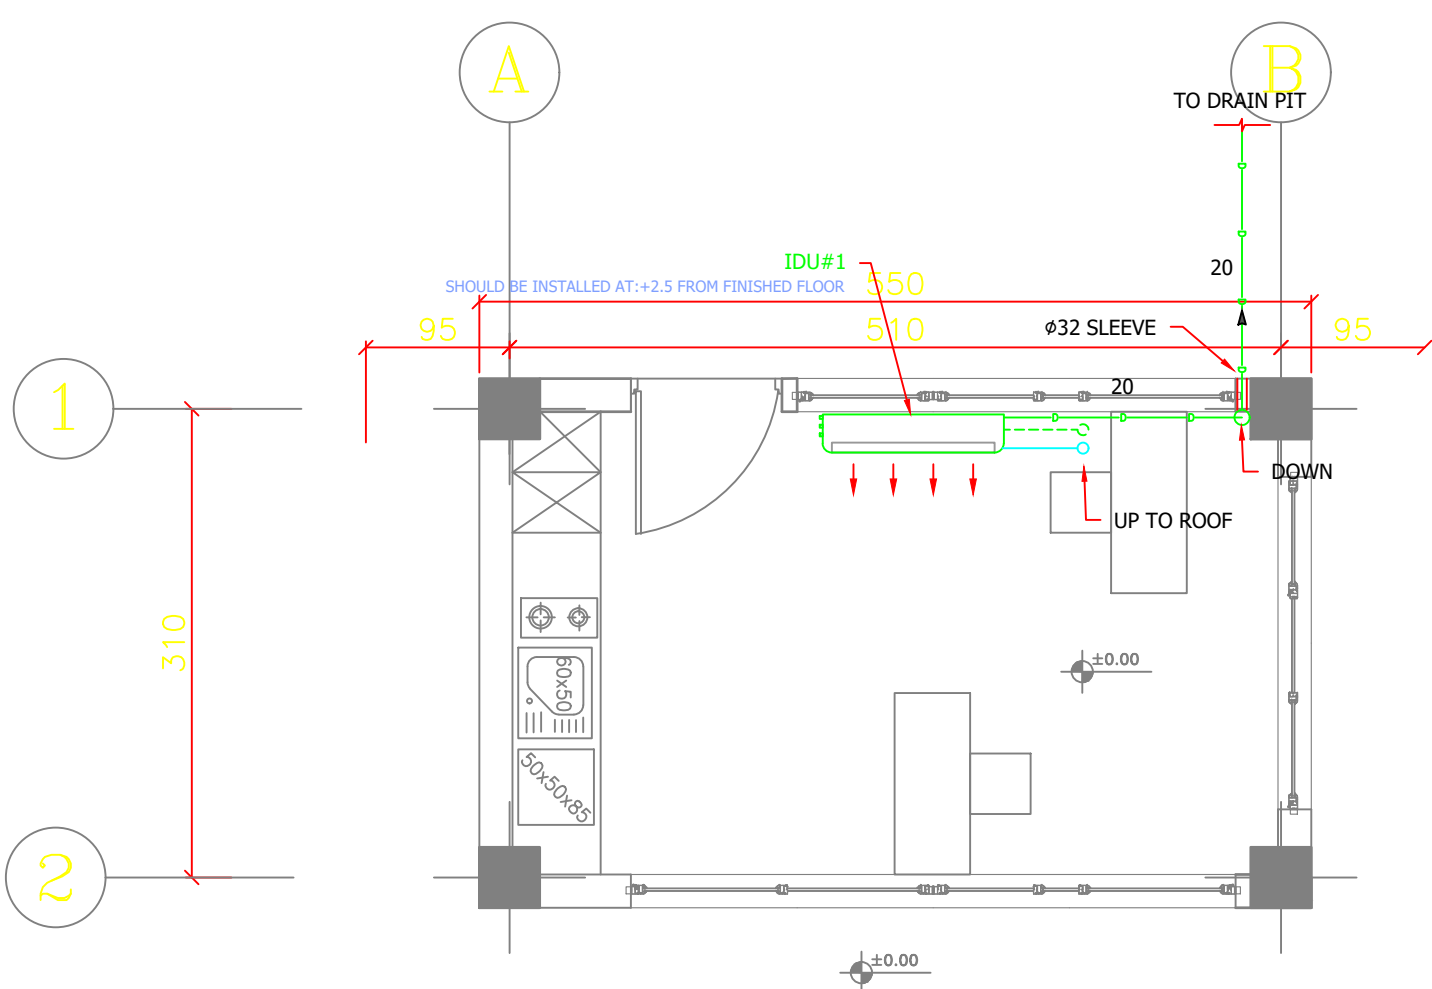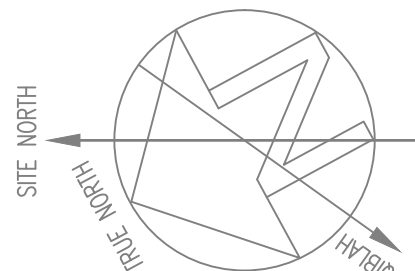


THIS PRINT AND ALL THE INFORMATION HEREON IS THE PROPERTY OF BARSOO MUST NOT BE MADE PUBLIC, COPIED OR USED IN ANY WAY DETRIMENTAL TO OUR INTEREST. IT IS LOANED SUBJECT TO RETURN ON DEMAND, UNLESS FURNISHED UNDER CONTRACT.

THIS PRINT AND ALL THE INFORMATION HEREON IS THE PROPERTY OF BARSOO MUST NOT BE MADE PUBLIC, COPIED OR USED IN ANY WAY DETRIMENTAL TO THIS INTEREST. IT IS LOANED SUBJECT TO RETURN ON DEMAND, UNLESS FURNISHED UNDER CONTRACT.

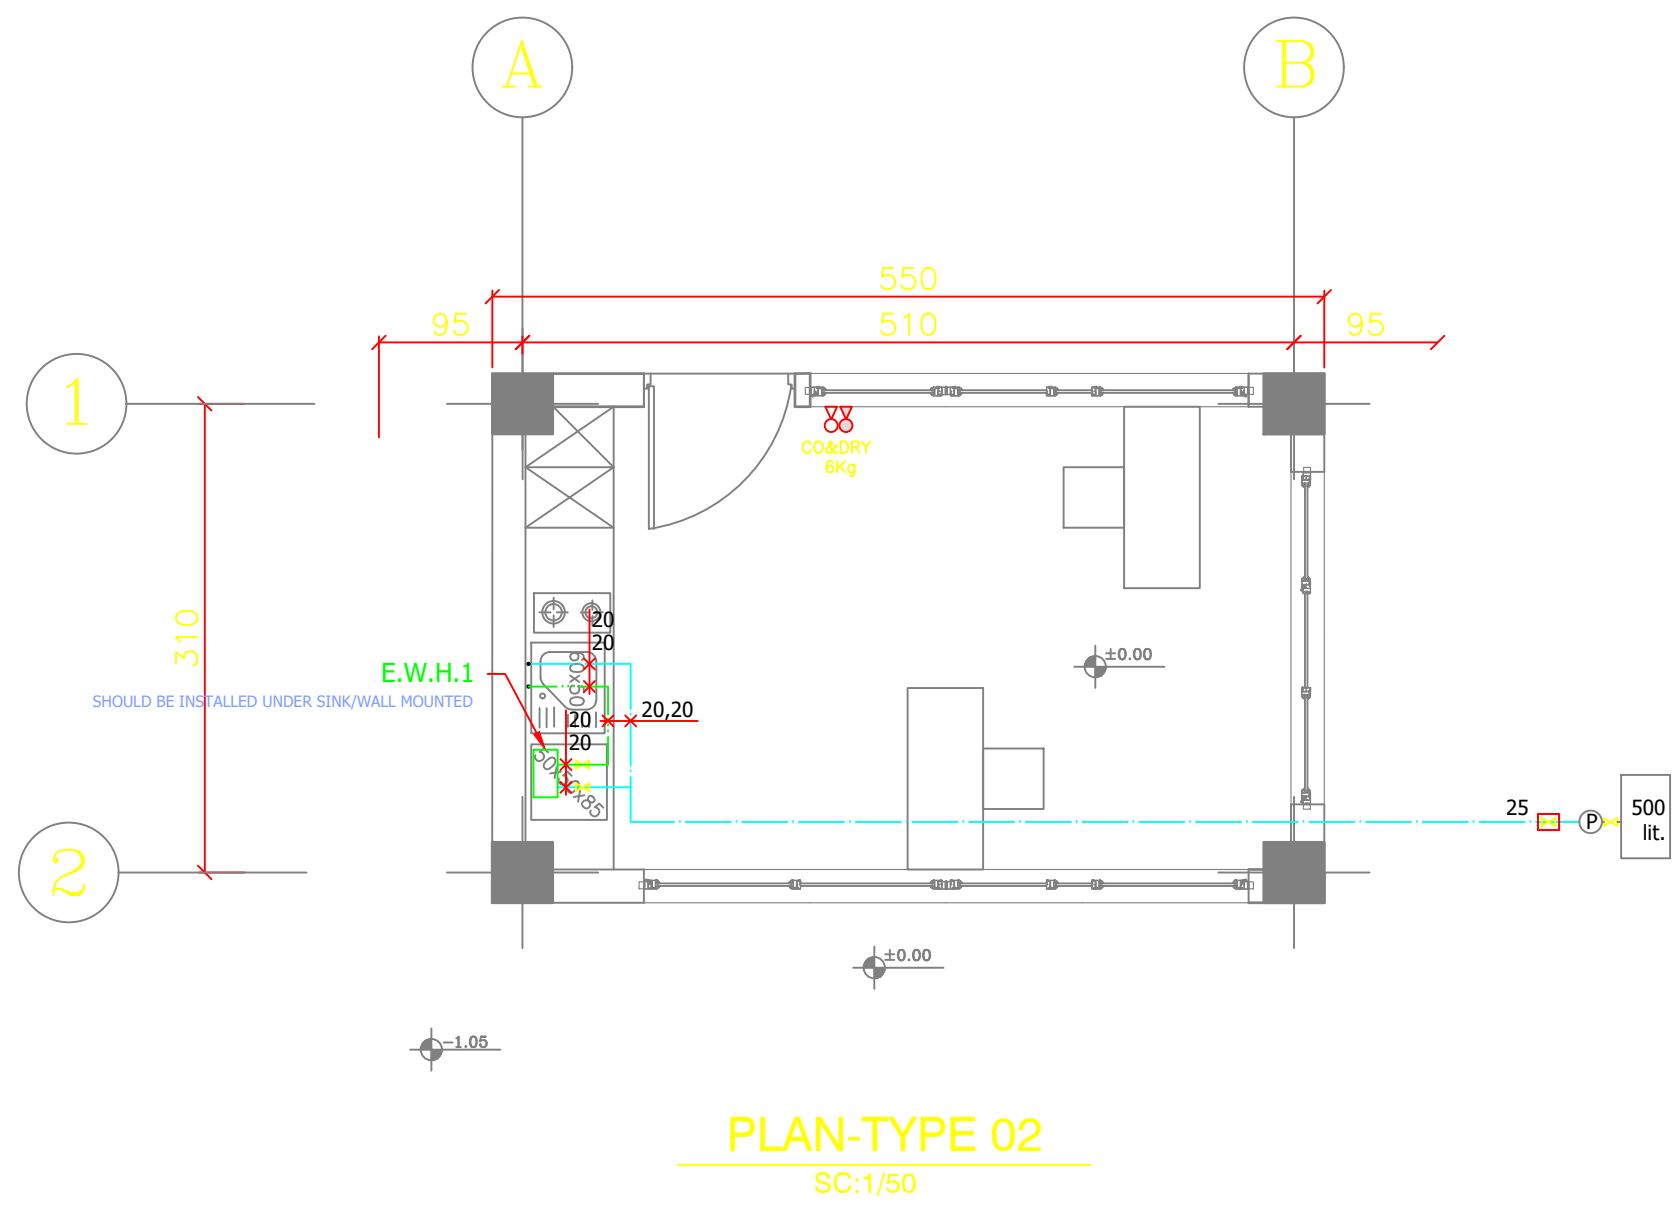

ارتفاع نصب لوله ها و تجهیزات از کف تمام شده	
ارتفاع نصب (cm)	مشخصات سرویس یا تجهیزات
85	دستشویی
105	ظرفشویی یا شیر دیواری
55	ظرفشویی یا شیر تو صفحه ای
40	شیر مخلوط یا تکی توالت
80	شیر مخلوط دوش
180	شیر پیسوار فلش تانک
100	فلش والو
40	لوله فاضلاب دستشویی
55	لوله فاضلاب ظرفشویی
80-180	لوله تصایي ونت از کف بام
15.5-16.5 cm	فاصله مرکز به مرکز شیر مخلوط

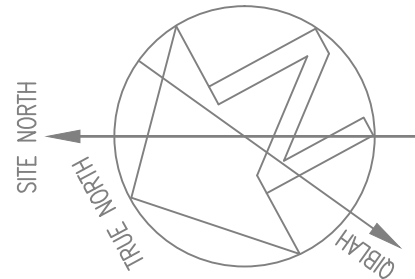


REFERENCES

NOTE

لوله آب مصرفی در عمق ۱۴۰- سانتی متر بصورت دفنی اجرا شود.
در مقاطع عبور کامیون از روی لوله (امتداد باسکول ها) میبایست اسلب بتنی کارشود.

KEY PLAN

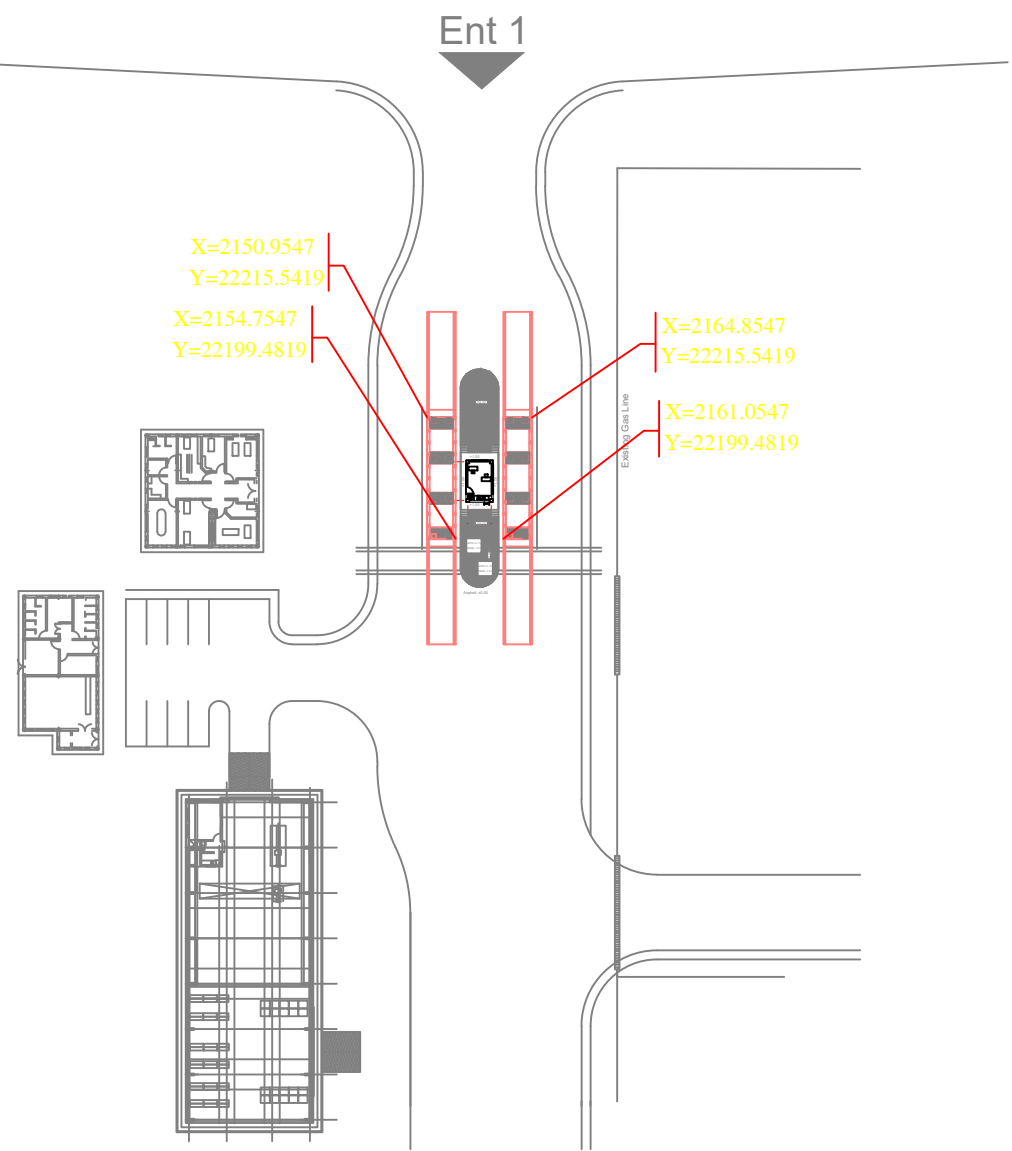

Rev.	Date	Revisions description	Prepared	Checked	Approved
-	-	-	-	-	-

for APPROVAL

CLIENT:
Golgozar Iron & Steel Development Co.
شرکت توسعه آهن و فولاد گل گهر
G.I.S.D.Co

CONSULTANT:
برسو
BARSOO
CONSULTING AND PROJECT MANAGEMENT
شرکت مهندسی

CONTRACTOR:

SUBCONTRACTOR:



Name	Date:	Sign.	CLIENT DOC . NO.		
Approved	AM.MONFARED	1405/04/08			
Checked:	F.RONAGH	1405/04/08	PROJECT NO.:		
Designed:	J.SHARIF	1405/04/06	SCALE as shown	DOC CLASS NO.: --	

PROJECT: WEST WEIGHING STATION


DRAWING TITLE:
FIRE FIGHTING AND POTABLE WATER PLAN

DRAWING NO.										
REGION CODE	PROJECT CODE	SUB PHASE CODE	AREA CODE	UNIT CODE	DOC TYPE CODE	DISCIPLINE CODE	SERIAL NO	REV	SIZE	SHEET
S	LM01	D	LIM	WHS	DWG	UT	003	0	A1	1/1

THIS PRINT AND ALL THE INFORMATION HEREON IS THE PROPERTY OF BARSOO MUST NOT BE MADE PUBLIC, COPIED OR USED IN ANY WAY DETRIMENTAL TO OUR INTEREST. IT IS LOANED SUBJECT TO RETURN ON DEMAND, UNLESS FURNISHED UNDER CONTRACT.

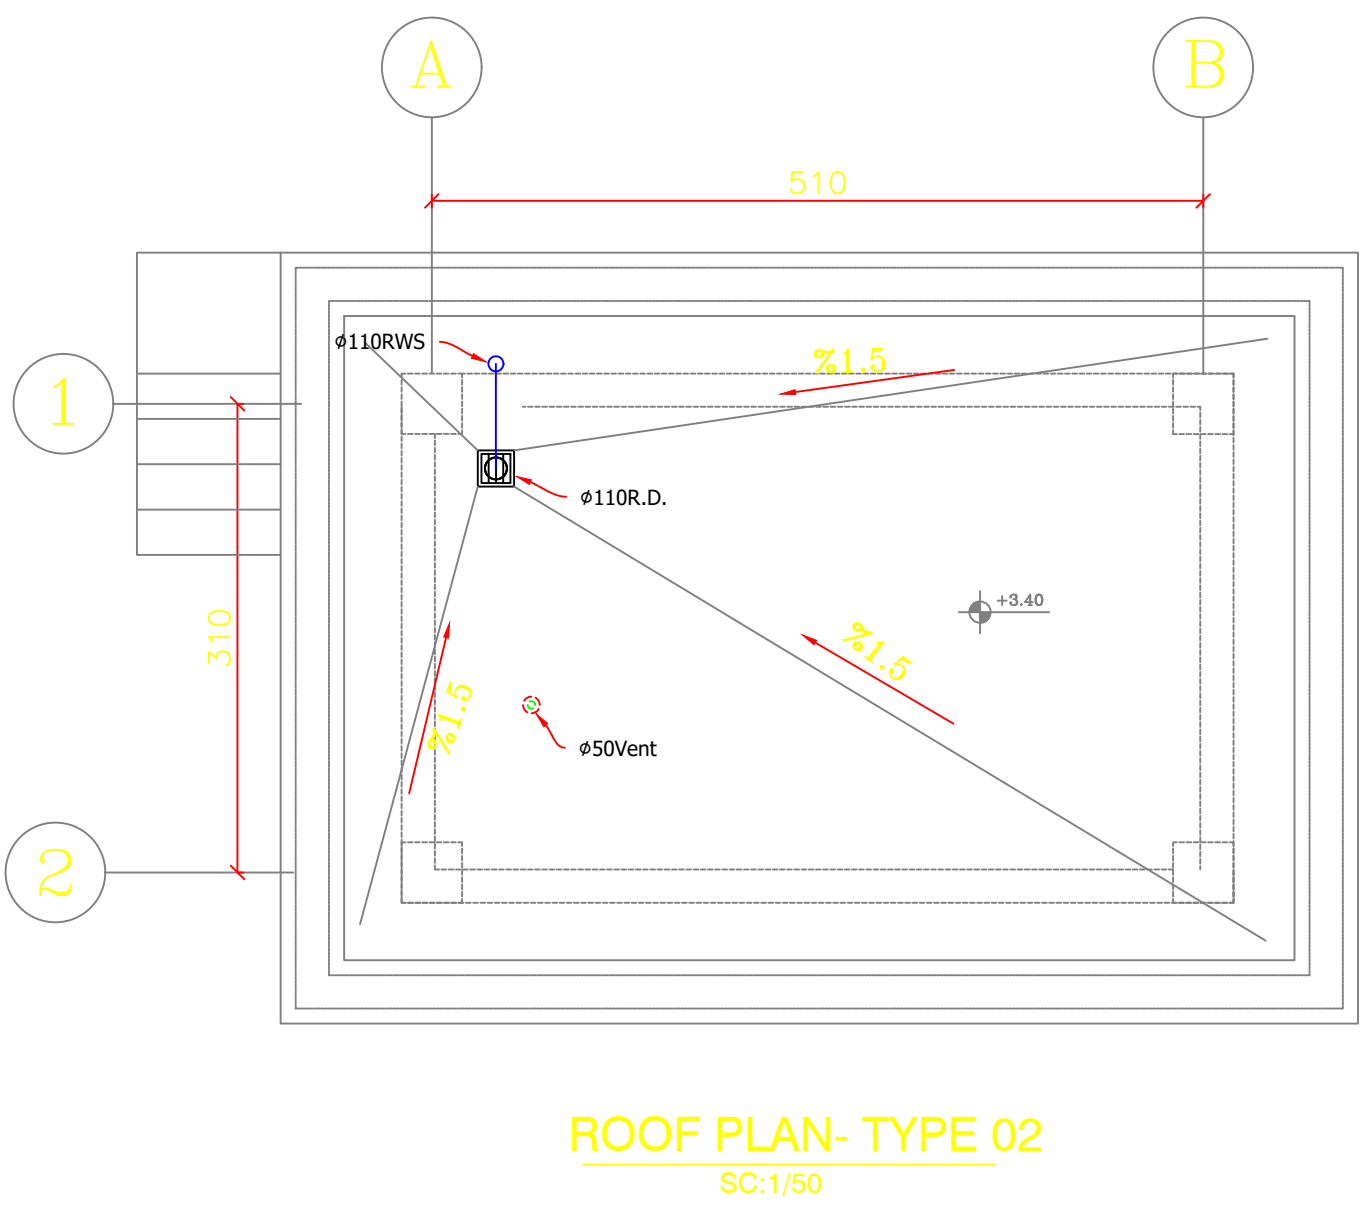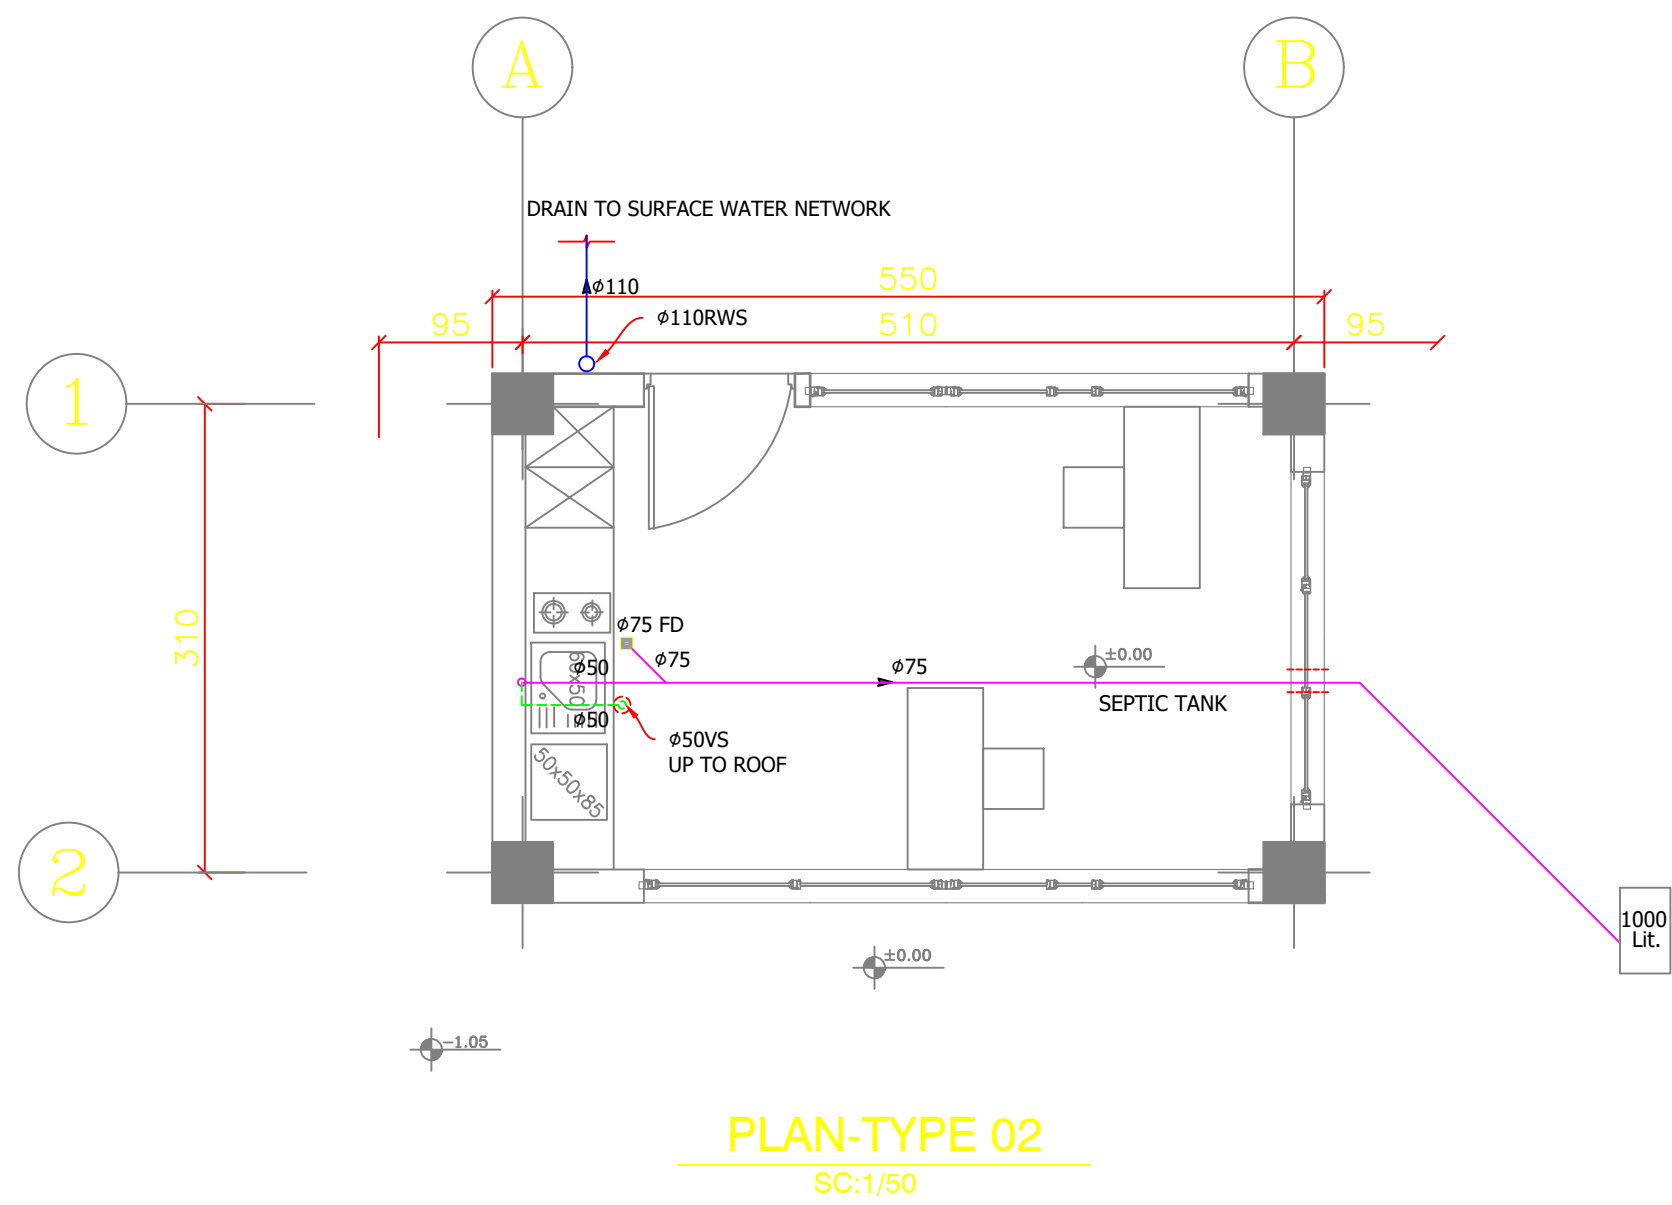


ارتفاع نصب لوله ها و تجهیزات از کف تمام شده	
مشخصات سرویس یا تجهیزات	ارتفاع نصب (cm)
دستشویی	85
ظرفشویی یا شیر دیواری	105
ظرفشویی یا شیر توکنه ای	55
شیر مخلوط یا تکی نوال	40
شیر مخلوط دوش	80
شیر پیسوار فلانی تانک	180
فلانی والو	100
لوله فاضلاب دستشویی	40
لوله فاضلاب ظرفشویی	55
لوله عمایی ونت از کف بام	80-180
فاصله مرکز به مرکز شیر مخلوط	15.5-16.5 cm

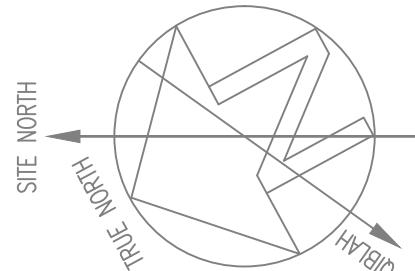

REFERENCES

NOTE

KEY PLAN

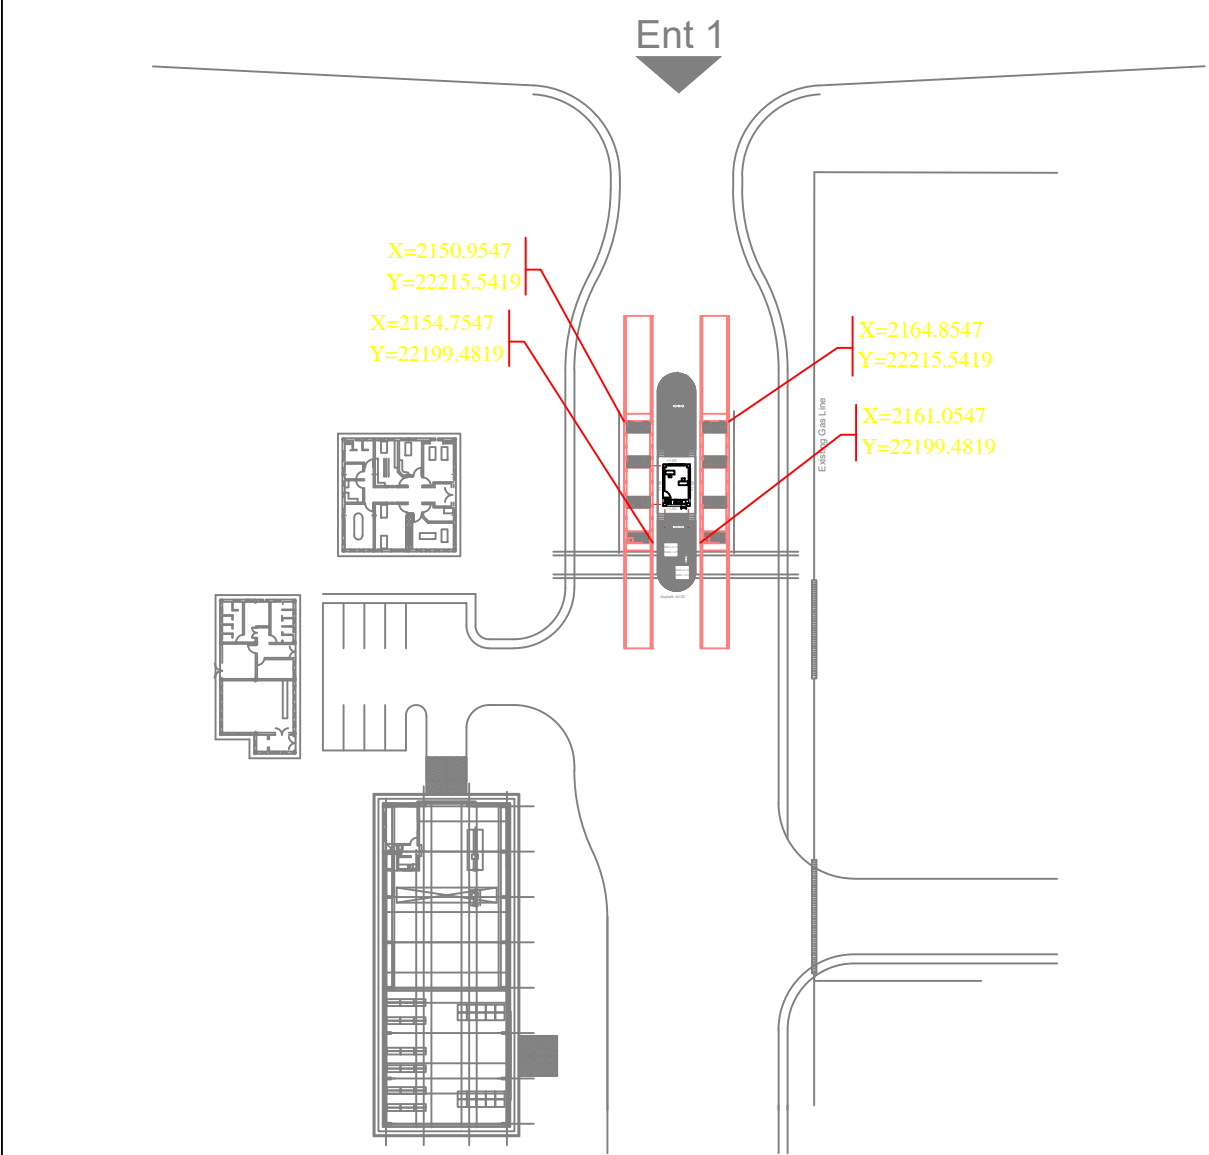

Rev.	Date	Revisions description	Prepared	Checked	Approved
-	-	-	-	-	-

for APPROVAL

CLIENT: Golgozar Iron & Steel Development Co. شرکت توسعه آهن و فولاد گل گهر G.I.S.D.Co.	CONSULTANT: برسو BARSOO CONSULTING AND PROJECT MANAGEMENT شرکت مهندسی
--	---




CONTRACTOR:	SUBCONTRACTOR:
-------------	----------------

	Name	Date:	Sign.	CLIENT DOC . NO.	
Approved	AM.MONFARED	1405/04/08			
Checked:	F.RONAGH	1405/04/08		PROJECT NO.:	
Designed:	J.SHARIF	1405/04/06		SCALE as shown	DOC CLASS NO.: --

PROJECT:	WEST WEIGHING STATION
DRAWING TITLE:	SEWAGE, VENT AND RAIN DRAINAGE PLAN

DRAWING NO.										
REGION CODE	PROJECT CODE	SUB PHASE CODE	AREA CODE	UNIT CODE	DOC TYPE CODE	DISCIPLINE CODE	SERIAL NO	REV	SIZE	SHEET
S	LM01	D	LIM	WHS	DWG	UT	004	0	A1	1/1


THIS PRINT AND ALL THE INFORMATION HEREON IS THE PROPERTY OF BARSOO MUST NOT BE MADE PUBLIC, COPIED OR USED IN ANY WAY DETRIMENTAL TO OUR INTEREST. IT IS LOANED SUBJECT TO RETURN ON DEMAND, UNLESS FURNISHED UNDER CONTRACT.

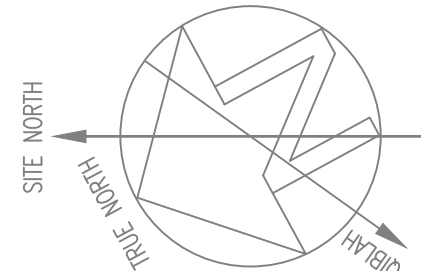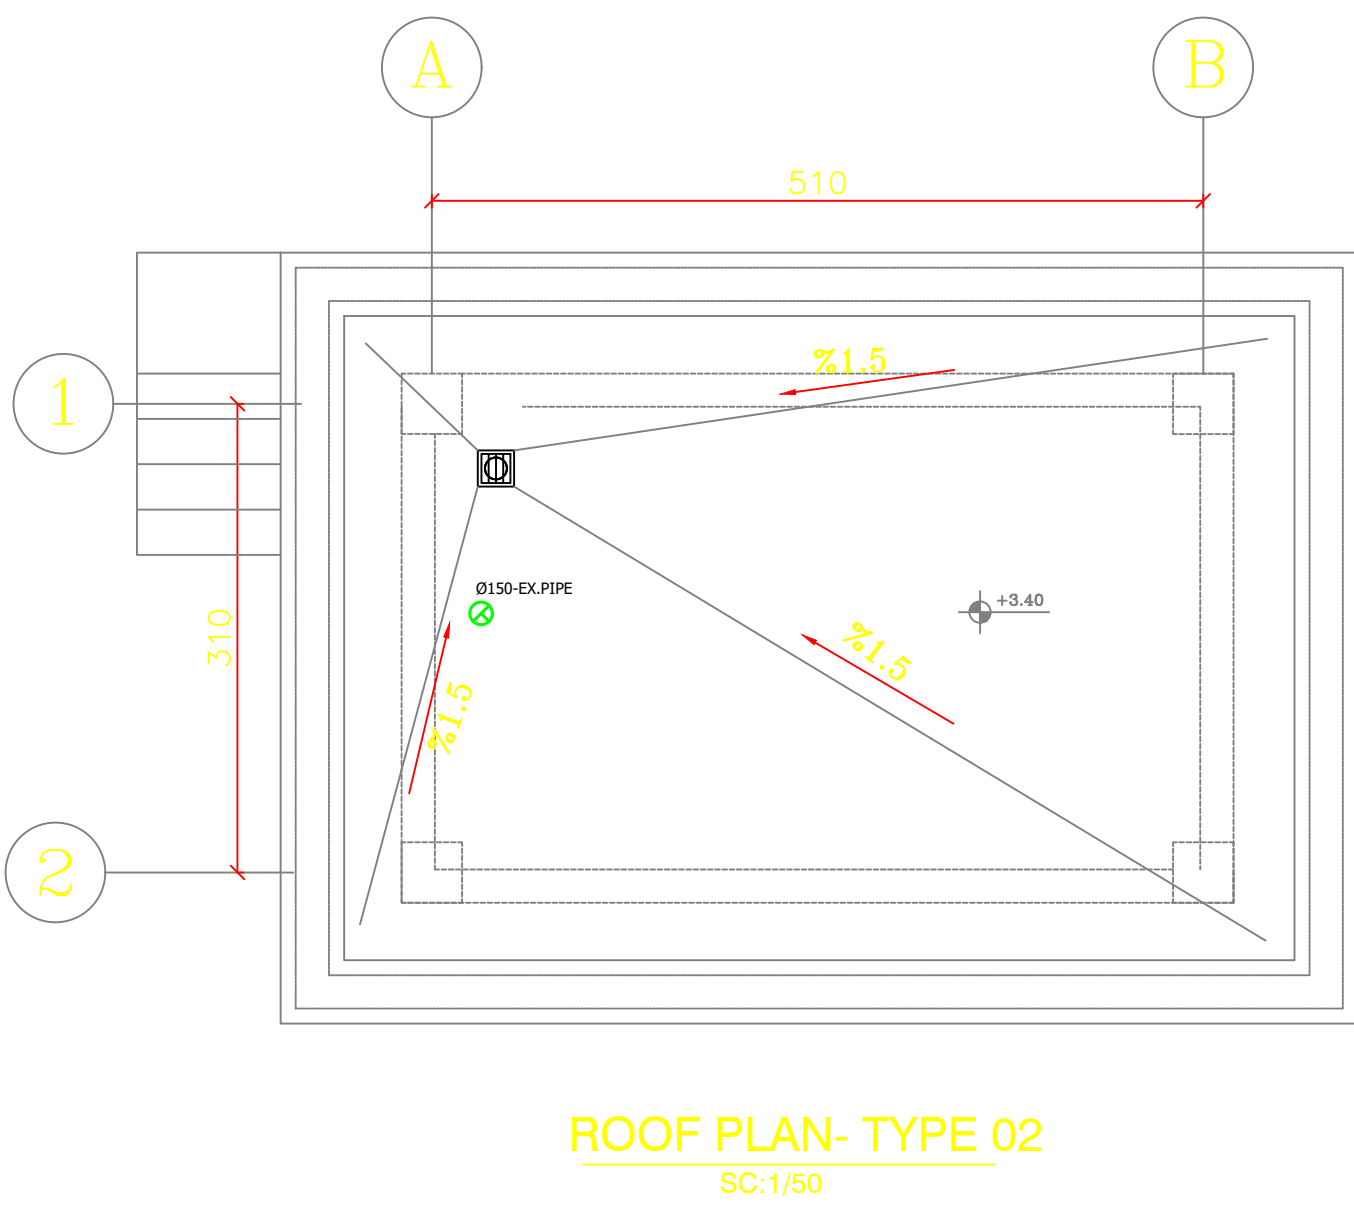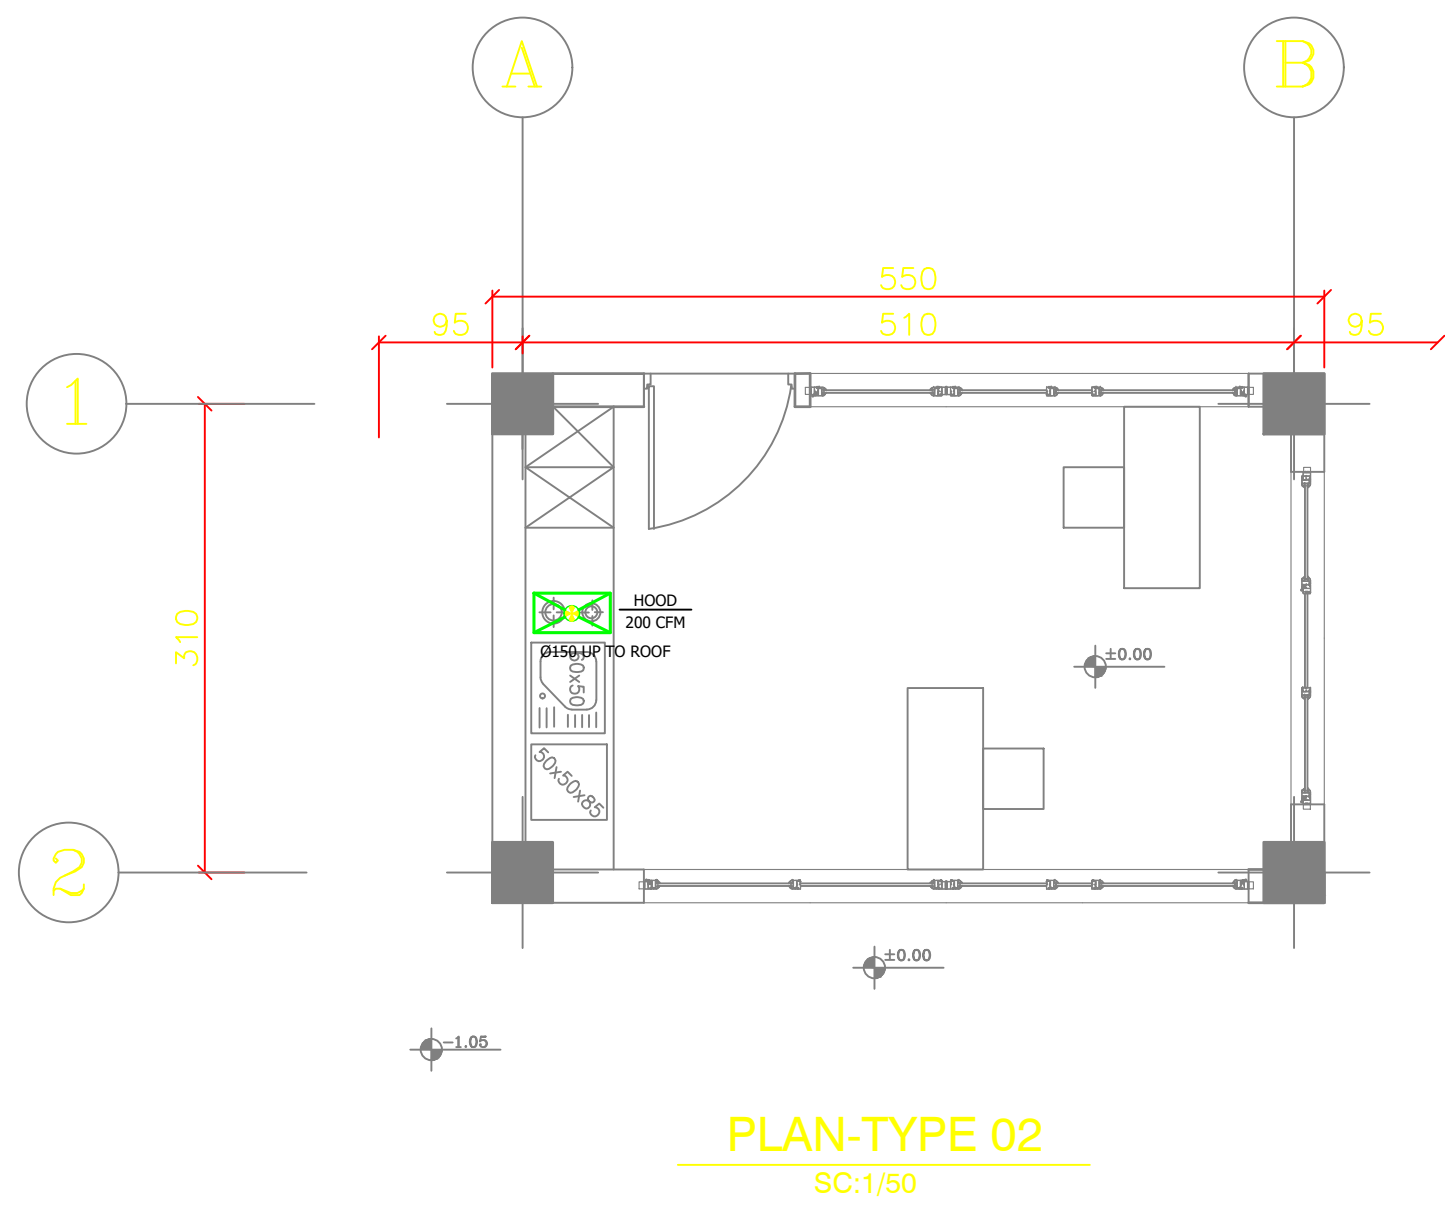

REFERENCES

NOTE

KEY PLAN

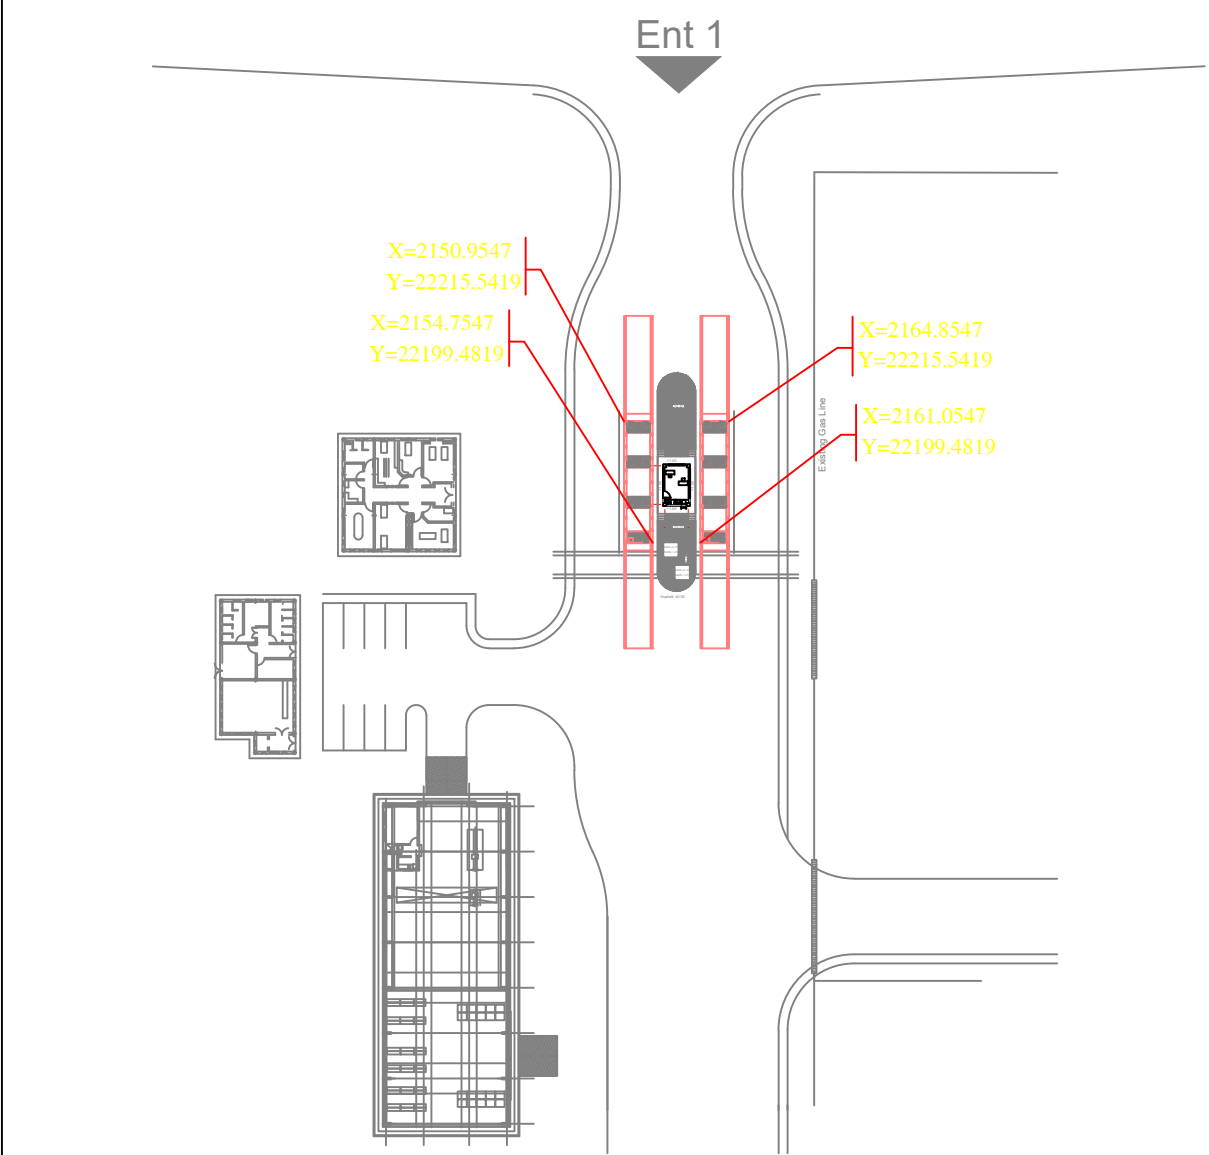

-	-	-	-	-	-
Rev.	Date	Revisions description	Prepared	Checked	Approved

for APPROVAL

CLIENT: Golgozar Iron & Steel Development Co. شرکت توسعه آهن و فولاد گل گهر G.I.S.D.Co.				CONSULTANT: برسو BARSOO CONSULTING and PROJECT MANAGEMENT						
CONTRACTOR:				SUBCONTRACTOR:						
		Name	Date:	Sign.	CLIENT DOC . NO.					
Approved		AM.MONFARED	1405/04/08							
Checked:		F.RONAGH	1405/04/08		PROJECT NO.:					
Designed:		J.SHARIF	1405/04/06		SCALE as shown	DOC CLASS NO.: --				
PROJECT:		WEST WEIGHING STATION								
DRAWING TITLE:										
EXHAUST PLAN										
DRAWING NO.										
REGION CODE	PROJECT CODE	SUB PHASE CODE	AREA CODE	UNIT CODE	DOC TYPE CODE	DISCIPLINE CODE	SERIAL NO	REV	SIZE	SHEET
S	LM01	D	LIM	WHS	DWG	UT	005	0	A1	1/1

THIS PRINT AND ALL THE INFORMATION HEREON IS THE PROPERTY OF BARSOO MUST NOT BE MADE PUBLIC, COPIED OR USED IN ANY WAY DETRIMENTAL TO THIS INTEREST. IT IS LOANED SUBJECT TO RETURN ON DEMAND, UNLESS FURNISHED UNDER CONTRACT.

PUMP SCH.								
ITEM	QTY	QTY.	FLOW (CFM)	PD. (Pa)	ELECTRICAL DATA		FILTER TYPE	MODEL
					V-PH-HZ	POWER		
PUMP	1	1	—	—	220-1-50	300 w	—	PENTAX OR SIMILAR

جدول مشخصات هود اجاق گاز								
ITEM	QTY	FAN QTY.	FLOW (CFM)	PD. (Pa)	ELECTRICAL DATA		FILTER TYPE	MODEL
					V-PH-HZ	POWER		
HOOD	1	1	200	320	220-1-50	290W	ACRYLIC GREASE	SIMILAR TO BIMAX B 1002 U

جدول مشخصات آبگرمکن برقی											
NAME	QTY	TYPE	STORAGE CAPACITY LITER	ELECTRICAL DATA				DIM(MM)			REMARKS
				V	PH	Hz	POWER (kW)	W	D	H	
E.W.H.1	1	AUTOMATIC WALL TYPE	15	220	1	50	2	340	210	570	Ew Sun AZMOON KAR CO. OR SIMILAR

جدول مشخصات اسپلیت یونیت													
ITEM	TYPE	COOLING CAPACITY	HEATING CAPACITY	REFRIGERANT	ELECTRICAL DATA				PIPE CONNECTION			QTY.	MODEL
		BTU/HR	BTU/HR		V	PH	Hz	POWER (kW)	LIQUID (mm)	GAS (mm)	DRAIN (mm)		
#1	WALL-TYPE	24000	24000	R-410A	220	1	50	2.12	6.35	15.88	20	1	GWS-H24 P1T1A GREEN CO. OR SIMILAR

REFERENCES

NOTE

KEY PLAN

Rev.	Date	Revisions description	Prepared	Checked	Approved
-	-	-	-	-	-

for APPROVAL

CLIENT:

Golgohar Iron & Steel Development Co.
شرکت توسعه آهن و فولاد گل گهر
G.I.S.D.Co.

CONSULTANT:

برسو
BARSOO
CONSULTING AND PROJECT MANAGEMENT
شرکت مهندسی

CONTRACTOR:

SUBCONTRACTOR:


	Name	Date:	Sign.	CLIENT DOC . NO.	
Approved	AM.MONFARED	1405/04/08			
Checked:	F.RONAGH	1405/04/08		PROJECT NO.:	
Designed:	J.SHARIF	1405/04/06		SCALE as shown	DOC CLASS NO.: --

PROJECT: WEST WEIGHING STATION


DRAWING TITLE: EQUIPMENT SCHEDULES

DRAWING NO.


REGION CODE	PROJECT CODE	SUB PHASE CODE	AREA CODE	UNIT CODE	DOC TYPE CODE	DISCIPLINE CODE	SERIAL NO	REV	SIZE	SHEET
S	LM01	D	LIM	WHS	DWG	UT	006	0	A1	1/1

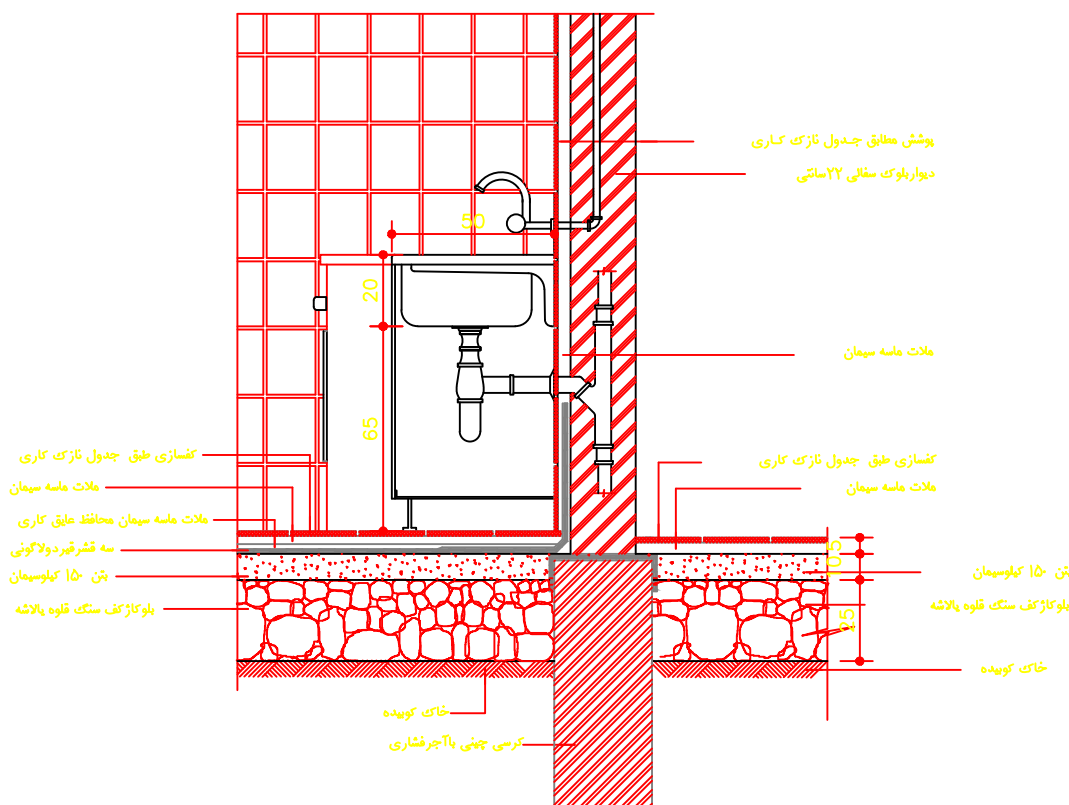

جزئیات نصب ظرفشویی

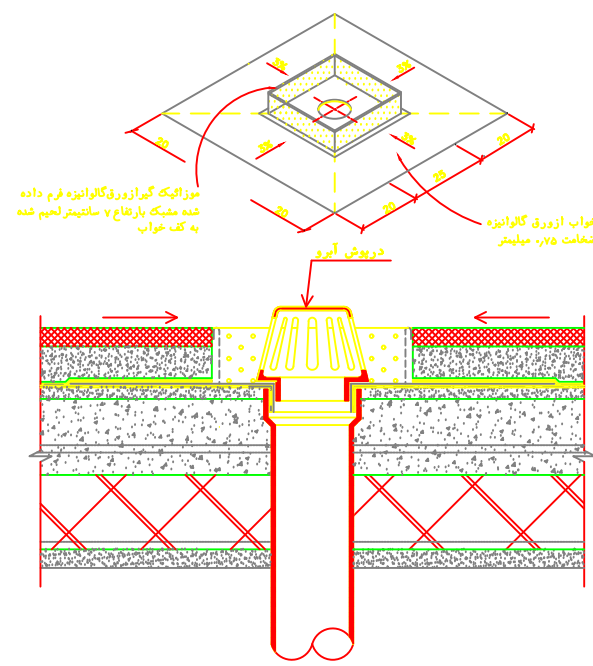

جزئیات کفشوی آب باران
N.T.S.

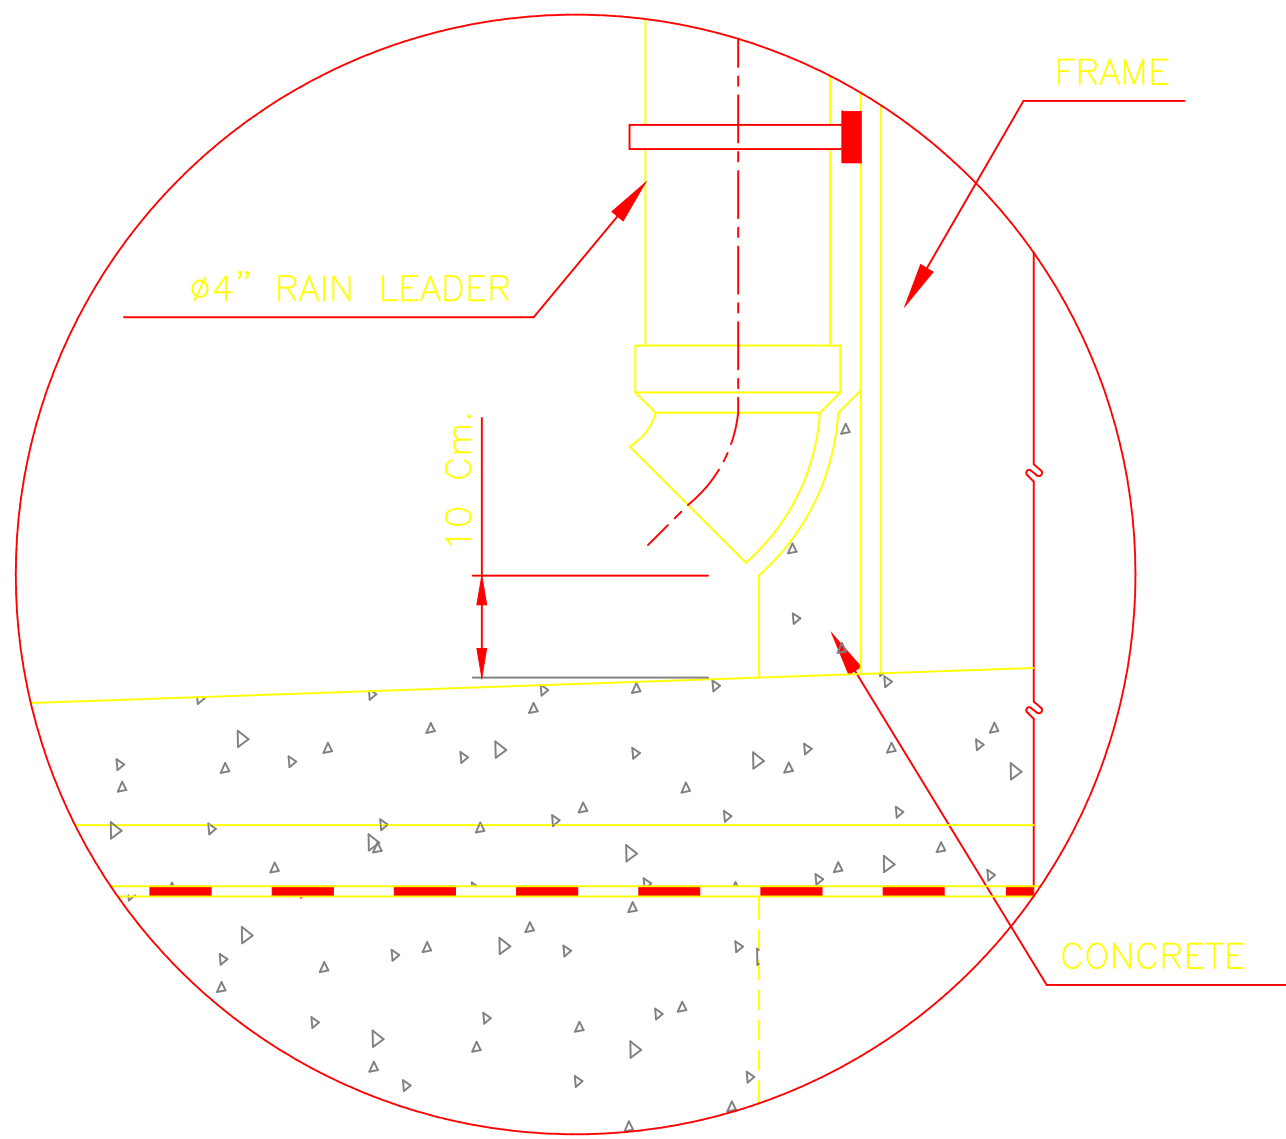


جزئیات رایزر آب باران
N.T.S.

REFERENCES

NOTE

KEY PLAN

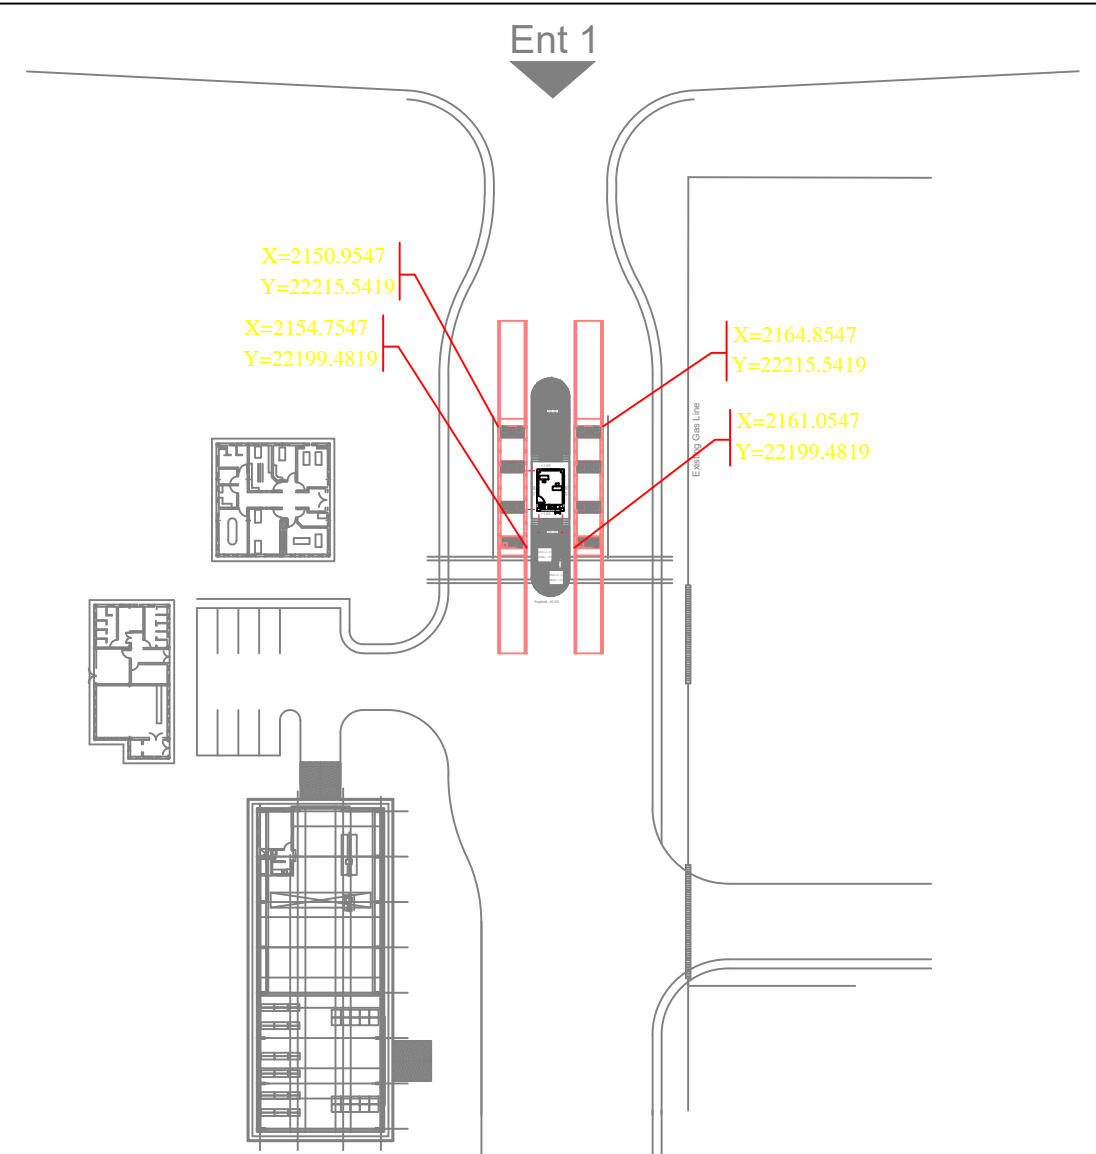

—	—	—	—	—	—
Rev.	Date	Revisions description	Prepared	Checked	Approved

for APPROVAL

CLIENT:
Golgothar Iron & Steel Development Co.
شرکت توسعه آهن و فولاد گل گهر
G.I.S.D.Co.

CONSULTANT:
BARSOO  **برسو**
CONSULTING and PROJECT MANAGEMENT شرکت مهندسی

CONTRACTOR:

SUBCONTRACTOR:

	Name	Date:	Sign.	CLIENT DOC . NO.	
Approved	AM.MONFARED	1405/04/08			
Checked:	F.RONAGH	1405/04/08		PROJECT NO.:	
Designed:	J.SHARIF	1405/04/06		SCALE as shown	DOC CLASS NO.: --


PROJECT:	WEST WEIGHING STATION
----------	-----------------------

DRAWING TITLE:

DRAWING NO.

REGION CODE	PROJECT CODE	SUB PHASE CODE	AREA CODE	UNIT CODE	DOC TYPE CODE	DISCIPLINE CODE	SERIAL NO	REV	SIZE	SHEET
S	LM01	D	LIM	WHS	DWG	UT	007	0	A1	1/1


THIS PRINT AND ALL THE INFORMATION HEREON IS THE PROPERTY OF BARSOO MUST NOT BE MADE PUBLIC, COPIED OR USED IN ANY WAY DETRIMENTAL TO THIS INTEREST. IT IS LOANED SUBJECT TO RETURN ON DEMAND, UNLESS FURNISHED UNDER CONTRACT.

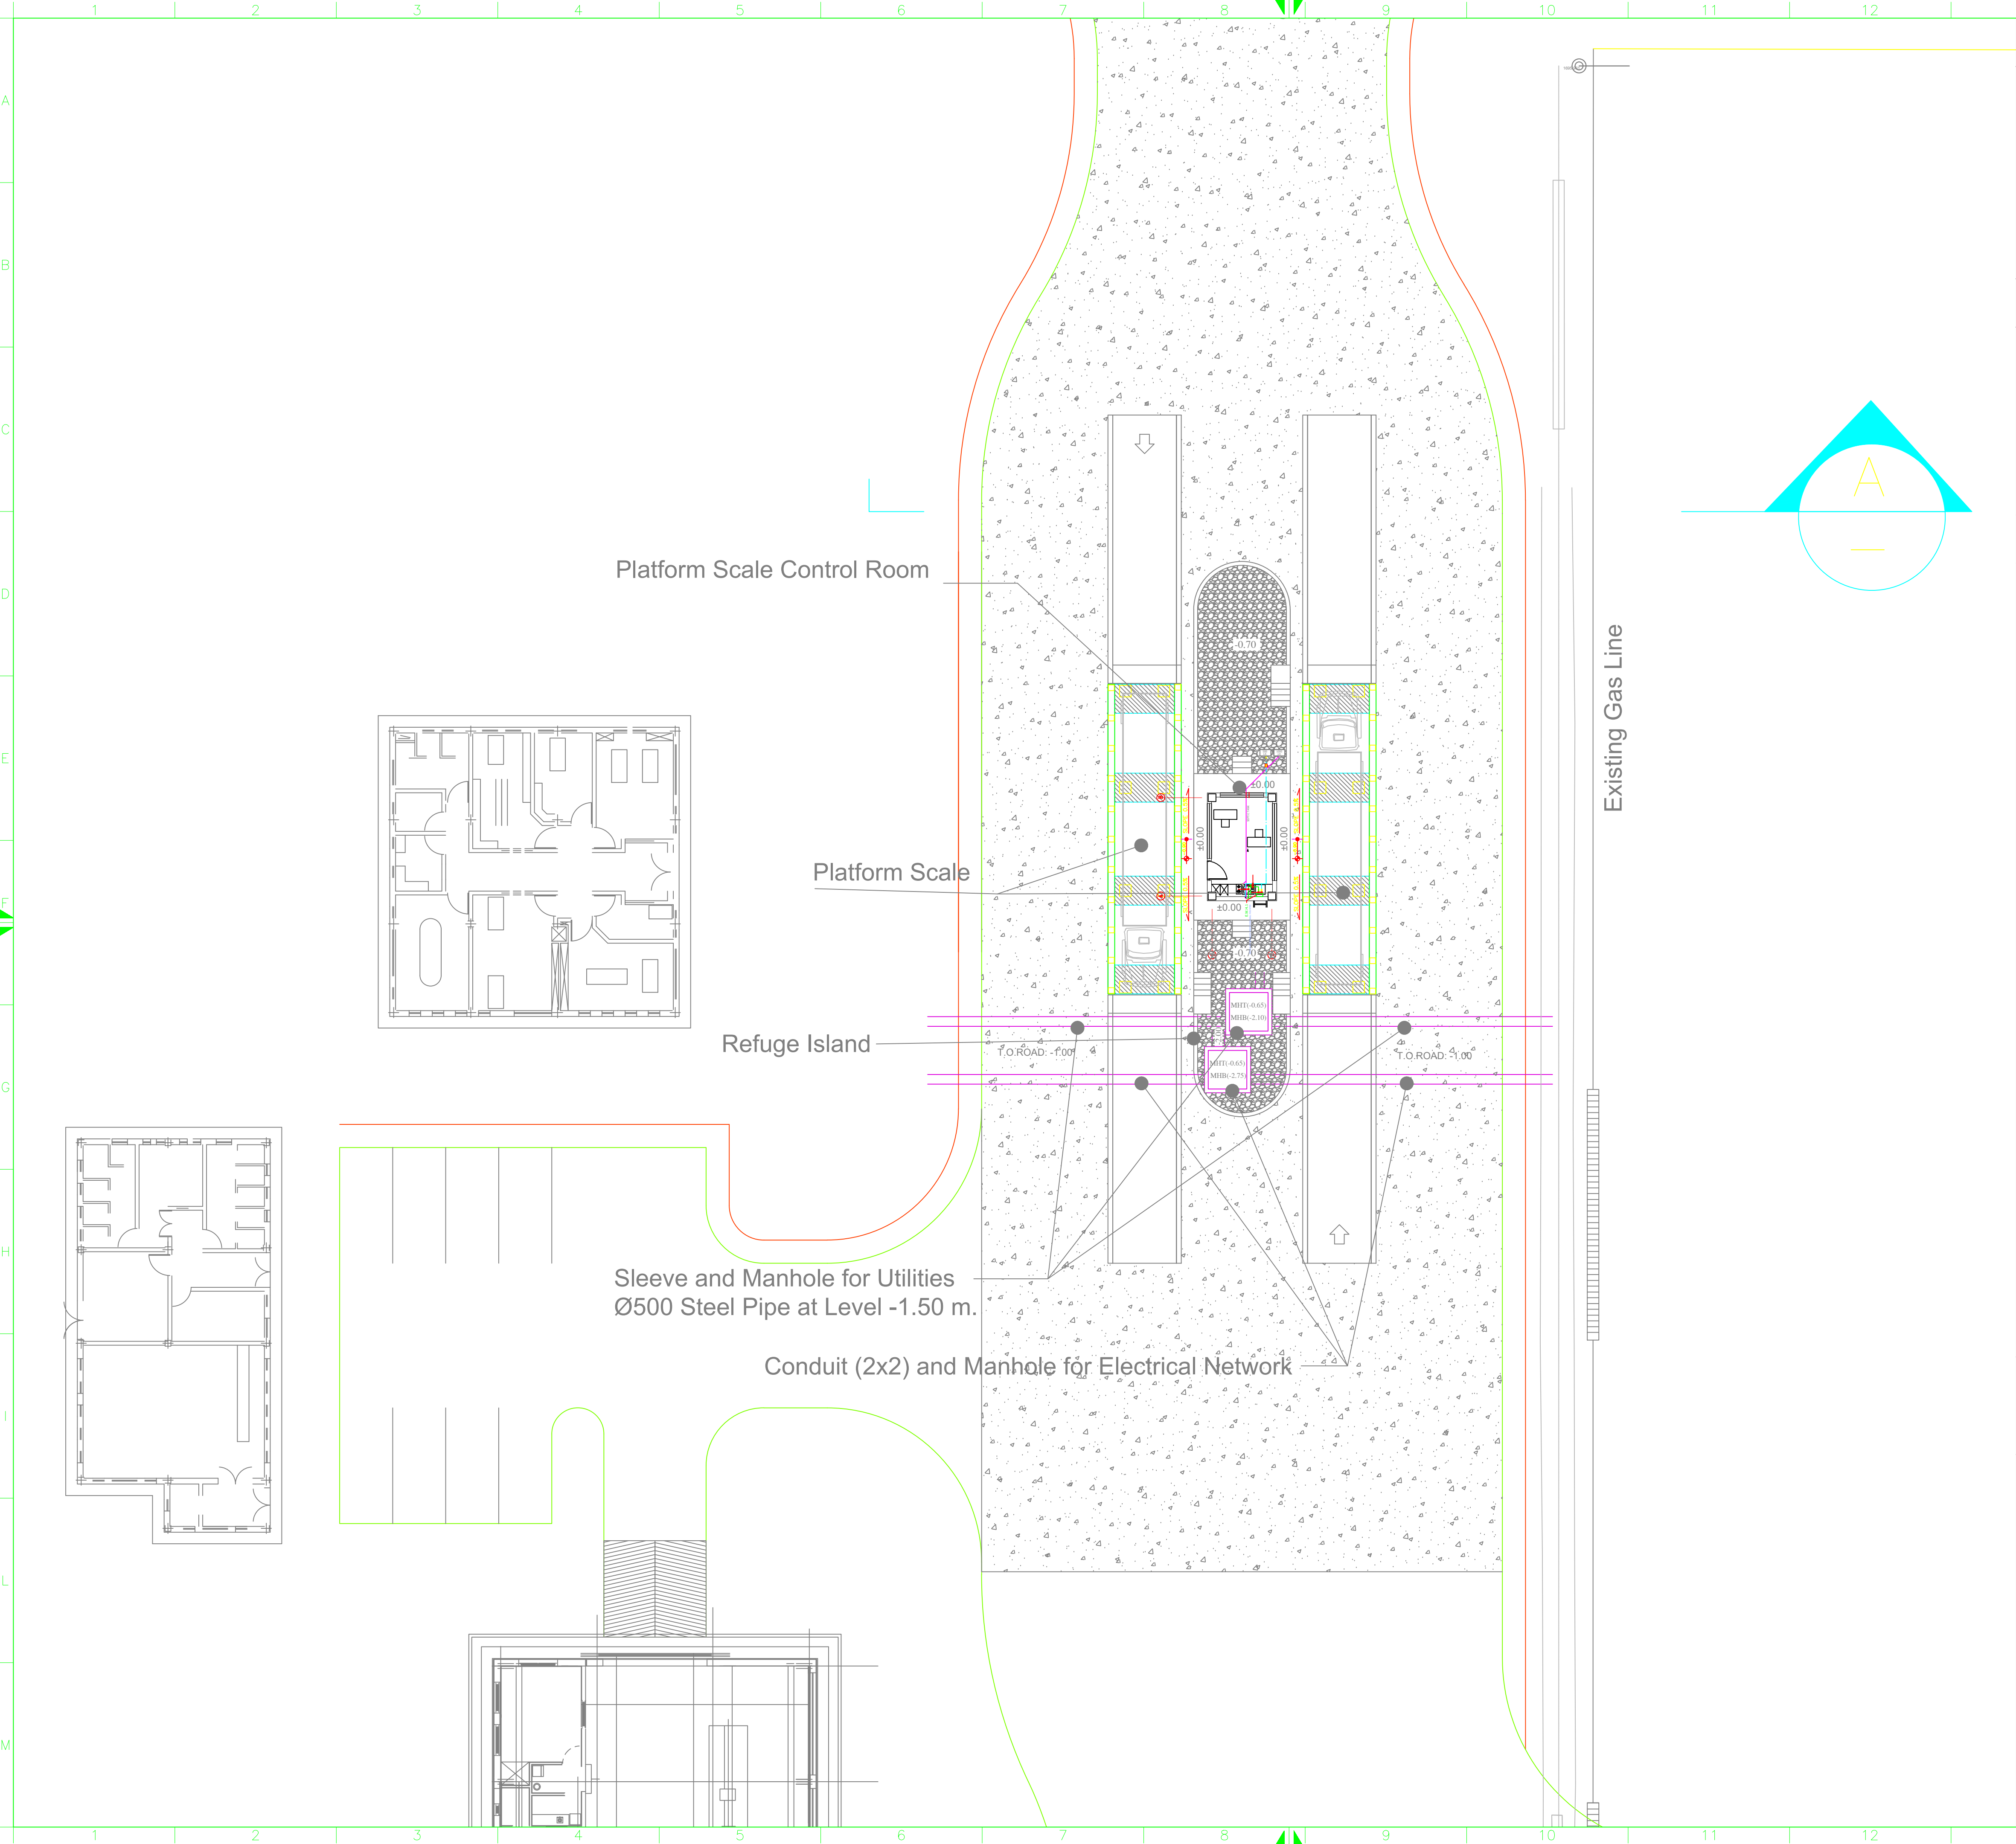

REFERENCES

NOTE

KEY PLAN

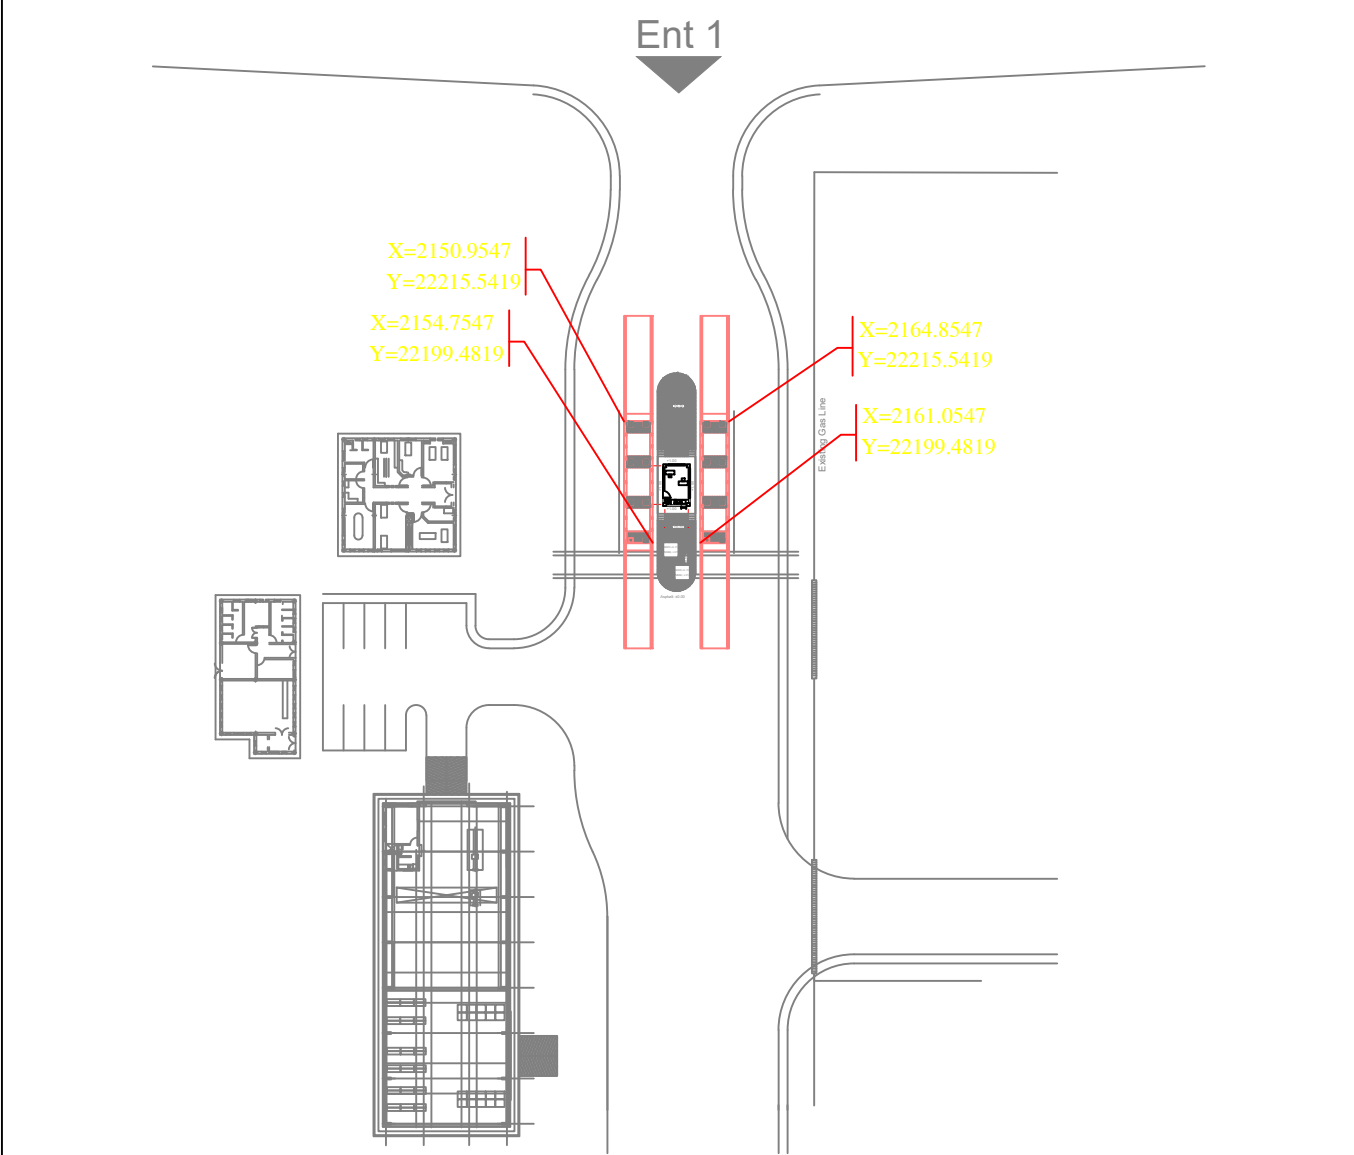

Rev.	Date	Revisions description	Prepared	Checked	Approved
-	-	-	-	-	-

for APPROVAL

CLIENT: Golgozar Iron & Steel Development Co. شرکت توسعه آهن و فولاد گل گهر G.I.S.D.Co	CONSULTANT: BARSOO برسو CONSULTING and PROJECT MANAGEMENT شرکت مهندسی
---	---

CONTRACTOR:				SUBCONTRACTOR:	
	Name	Date:	Sign.	CLIENT DOC . NO.	
Approved	AM.MONFARED	1405/04/08			
Checked:	F.RONAGH	1405/04/08		PROJECT NO.:	
Designed:	J.SHARIF	1405/04/06		SCALE as shown	DOC CLASS NO.: --

PROJECT:		WEST WEIGHING STATION								
DRAWING TITLE:		LAYOUT PLAN								
DRAWING NO.										
REGION CODE	PROJECT CODE	SUB PHASE CODE	AREA CODE	UNIT CODE	DOC TYPE CODE	DISCIPLINE CODE	SERIAL NO	REV	SIZE	SHEET
S	LM01	D	LIM	WHS	DWG	UT	009	0	A1	1/1