


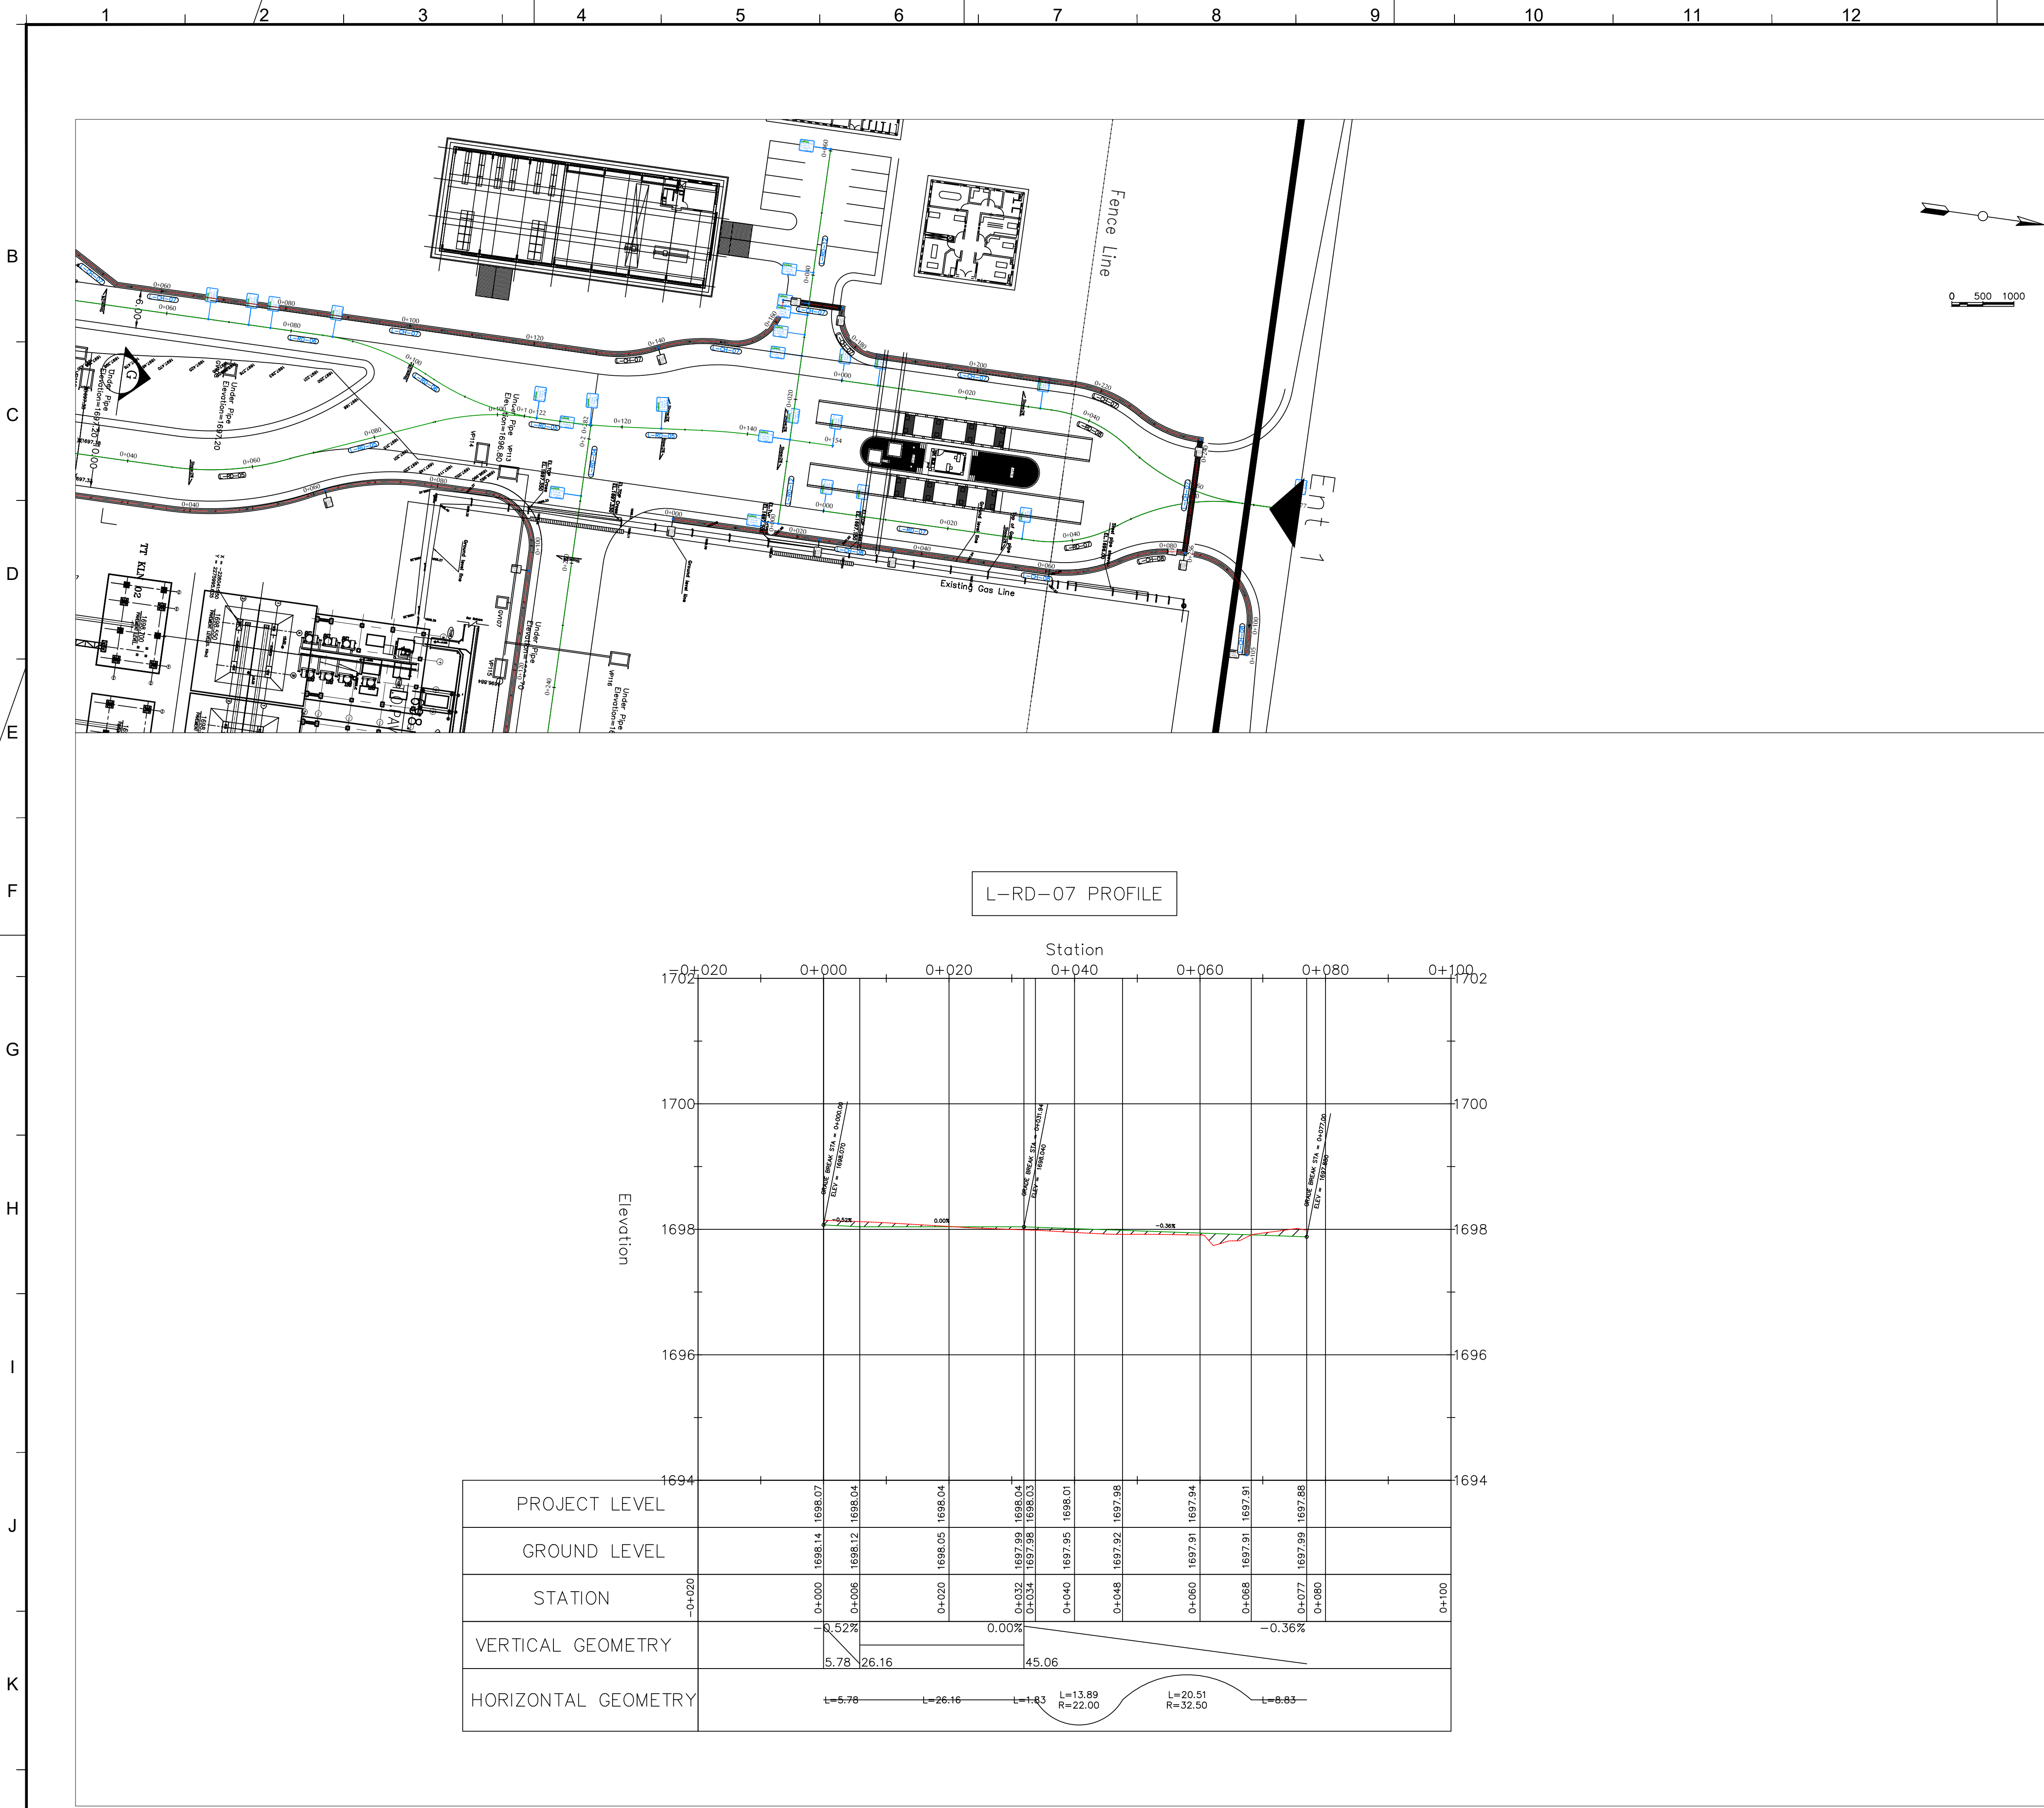

REFERENCE DOCUMENTS

No.

LEGEND :

خط زمین

جاده

NOTES:

- ALL DIMENSIONS AND ELEVATIONS ARE IN METERS.
- THE COORDINATE REFERENCE SYSTEM USED IN PLAN IS LOCAL.
- THE CONTRACTOR SHALL CHECK ALL DIMENSIONS ,CHANNEL LEVELS ,ROAD LEVELS AND GRADING LEVELS PRIOR TO EXECUTION OF ANY EARTH WORKS.
- THE CONTRACTOR SHALL TAKE INTO CONSIDERATION ALL THE NECESSARY ACTIVITIES TO BE ABLE TO DRAIN ALL THE SURFACE WATER BASED ON LEVELING DOCUMENTS.
- ROAD GEOMETRY DESIGN AND SITE PLAN IS IN ACCORDANCE WITH THE LATEST REVISION OF ARCHITECTURAL LAYOUT.
- IN ORDER TO PROVIDE CHANNEL DEPTHS, APPROPRIATE BACK FILL HEIGHT IS NEEDED ON SIDE OF ALL THE CHANNELS BANK.
- ALL THE EARTHWORKS SHALL BE DONE BASED ON " ROAD GENERAL TECHNICAL SPECIFICATION (2ND EDITION) (No.101_R2) "
- THE CONTRACTOR SHALL RECORD ALL THE SOIL LAYER HEIGHTS AND VOLUMES BASED ON VISUALCLASSIFICATION OF THE SOIL DURING EXCAVATION AT THE VERY AREA.
- CONTRACTOR HAS FULL RESPONSIBILITY IN CHECKING ALL DIMENSIONS AND QUANTITIES IN CONJUNCTION WITH OT ELECTRICAL, SANITARY AND STRUCTURAL DETAILS PRIOR TO CONSTRUCTION.
- THE SUPER ELEVATION DETAILS AND RELATED CONSTRUCTION LEVELS ARE IN ACCORDANCE WITH THE CROSS SECTION DOCUMENTS. A CORRECTION IS NEEDED ON CROSS SLOPES OF THE ROAD INTERSECTIONS AND IN THE HORIZONTAL CURVES.

KEY PLAN

for TENDER DOCUMENT

Rev.	DESCRIPTION	Prepared	Checked	Approved	Date
1	ISSUE FOR CONSTRUCTION	S.HONARVAR	A.KOSARIKH	A.MONFRED	1405.04.07
2	ISSUE FOR CONSTRUCTION	S.HONARVAR	A.KOSARIKH	A.MONFRED	1405.01.25

CLIENT:

شیرکت توسعه آهن و فولاد گل کهر

CONSULTANT:

BARSOO

CONTRACTOR:

SUBCONTRACTOR:

Name	Date	Sign.	CLIENT DOC . NO.
Approved	12/04/2020	--	S-LM01-D-LIM-GEN-DWG-CV-010
Checked:	12/04/2020	--	PROJECT NO.: 157DCGS0015213-01
Designed:	12/04/2020	--	SCALE AS SHOWN
PROJECT:	LIME PLANT CIVIL WORKS		

DRAWING TITLE: ROAD PLAN & PROFILE L-RD-07

REGION CODE	PROJECT CODE	SUB PHASE CODE	AREA CODE	UNIT CODE	DOC TYPE CODE	DISCIPLINE CODE	SERIAL NO	REV	SIZE	SHEET
S	LM01	D	LIM	GEN	DWG	CV	010	01	A1	1/1

File name:157DCGS0015213-01.DWG